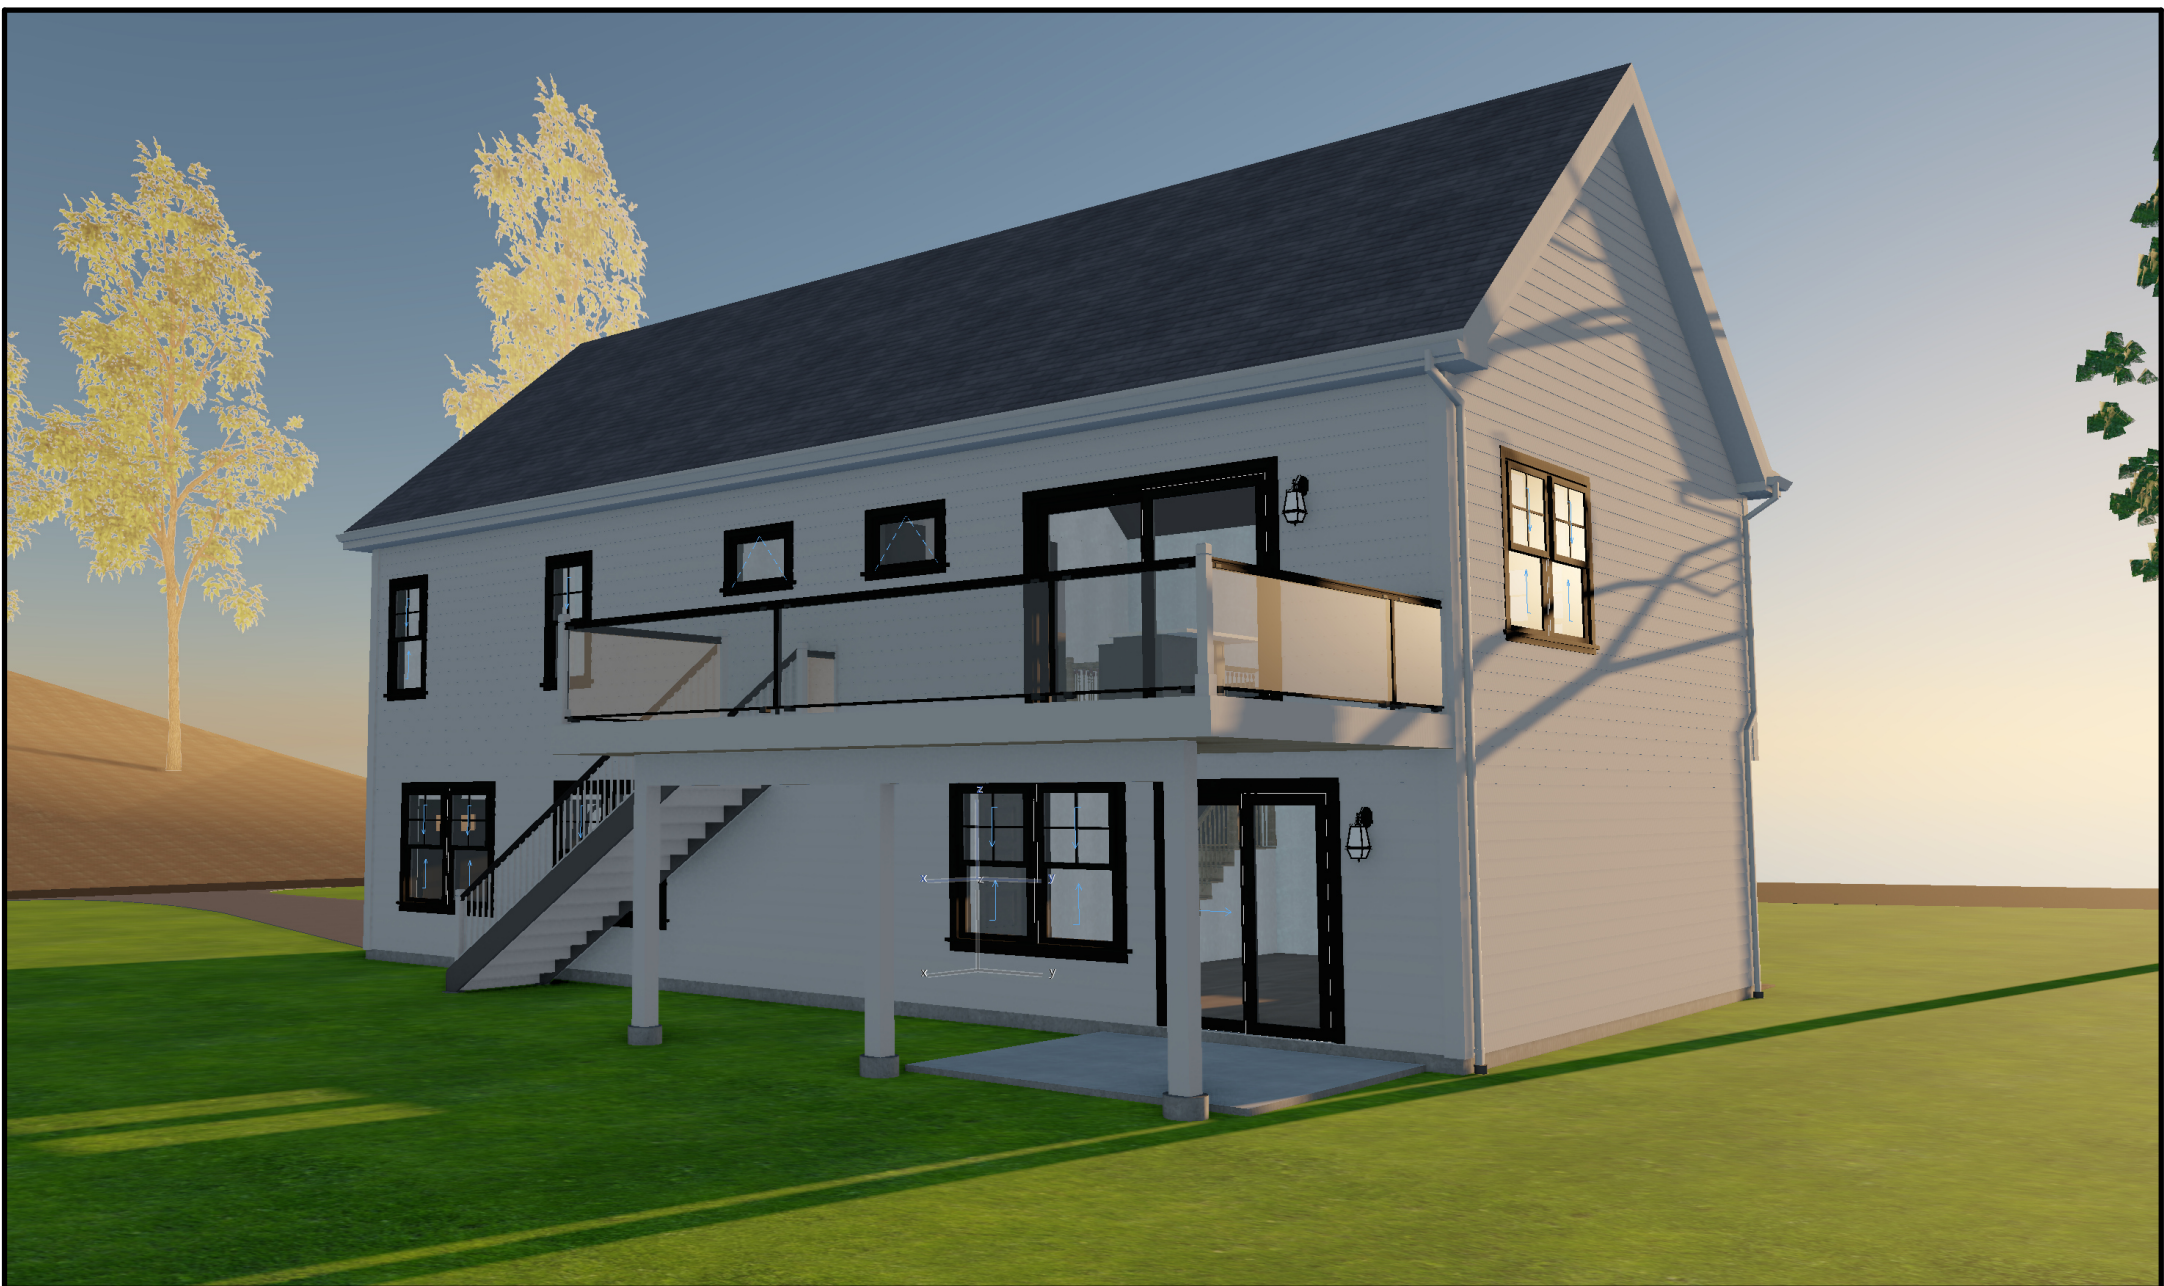




Drawing List	
G-001	Cover Sheet
G-002	Notes & Legends
AS-001	Site Plan
A-101	Floor Plans
A-102	Roof Plan
A-103	Electrical Plans
A-201	East & West Elevation
A-202	North & South Elevation
A-203	Interior Elevations
A-204	Interior Elevations
A-301	Building Sections
A-302	Wall Sections
A-501	Details
A-502	Details
A-503	Details
A-601	Openings Schedule
A-602	Finish Schedules
A-603	MEP Schedules

ROOM AREAS SCHEDULE			
FLOOR	ZONE	ROOM	AREA
First Floor	002	Laundry	36.71
			36.71 ft²
First Floor	006	Play Room	522.49
			522.49 ft²
First Floor	007	Garage	515.30
			515.30 ft²
First Floor	008	Full Bath	49.48
			49.48 ft²
First Floor	009	Mech.	13.53
			13.53 ft²
First Floor	022	Patio	155.99
			155.99 ft²
Second Floor	010	Living Room	232.85
			232.85 ft²
Second Floor	011	Primary Bath	60.25
			60.25 ft²
Second Floor	012	Hall Bath	52.23
			52.23 ft²
Second Floor	014	Bedroom #3	132.89
			132.89 ft²
Second Floor	015	Bedroom #2	126.15
			126.15 ft²
Second Floor	016	Primary Bedroom	164.55
			164.55 ft²
Second Floor	017	Hall	54.47
			54.47 ft²
Second Floor	018	Kitchen	137.39
			137.39 ft²
Second Floor	019	Dining Room	137.38
			137.38 ft²
Second Floor	020	Deck	264.00
			264.00 ft²
			2,655.66 ft²



CARDINAL DESIGN

211 Greenwood Avenue
Bethel, CT 06801
United States
www.cardinalde.com
projects@cardinalde.com

Raised Ranch

4 Old Neversink Road
Danbury Connecticut 06811
United States



CASALI COMPANIES
BUILDING ON TRUST

211 Greenwood Avenue
Bethel, CT 06801
United States
www.casalicompanies.com
projects@casalicompanies.com

PROJECT NO: 1006

MODEL FILE:
4 Old Neversink Road.pln

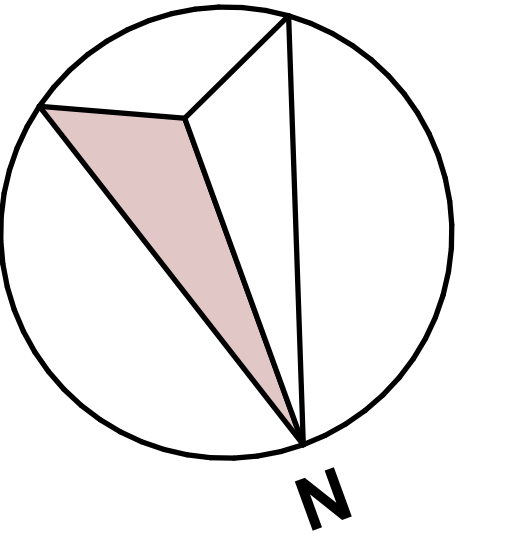
DRAWN BY: Jim Casali, Jr.

COPYRIGHT: 2025

SHEET TITLE

Cover Sheet





CONSULTANTS

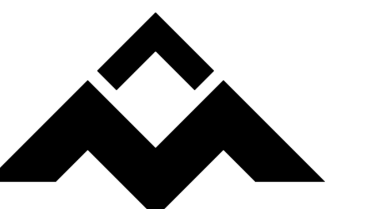


CARDINAL DESIGN

211 Greenwood Avenue
Bethel, CT 06801
United States
www.cardinalde.com
projects@cardinalde.com

Raised Ranch

4 Old Neversink Road
Danbury Connecticut 06811
United States



CASALI COMPANIES
BUILDING ON TRUST

211 Greenwood Avenue
Bethel, CT 06801
United States
www.casalicompanies.com
projects@casalicompanies.com

PROJECT NO: 1006

MODEL FILE:

4 Old Neversink Road.pln

DRAWN BY: Jim Casali, Jr.

COPYRIGHT: 2025


SHEET TITLE

Floor Plans

2



A-101

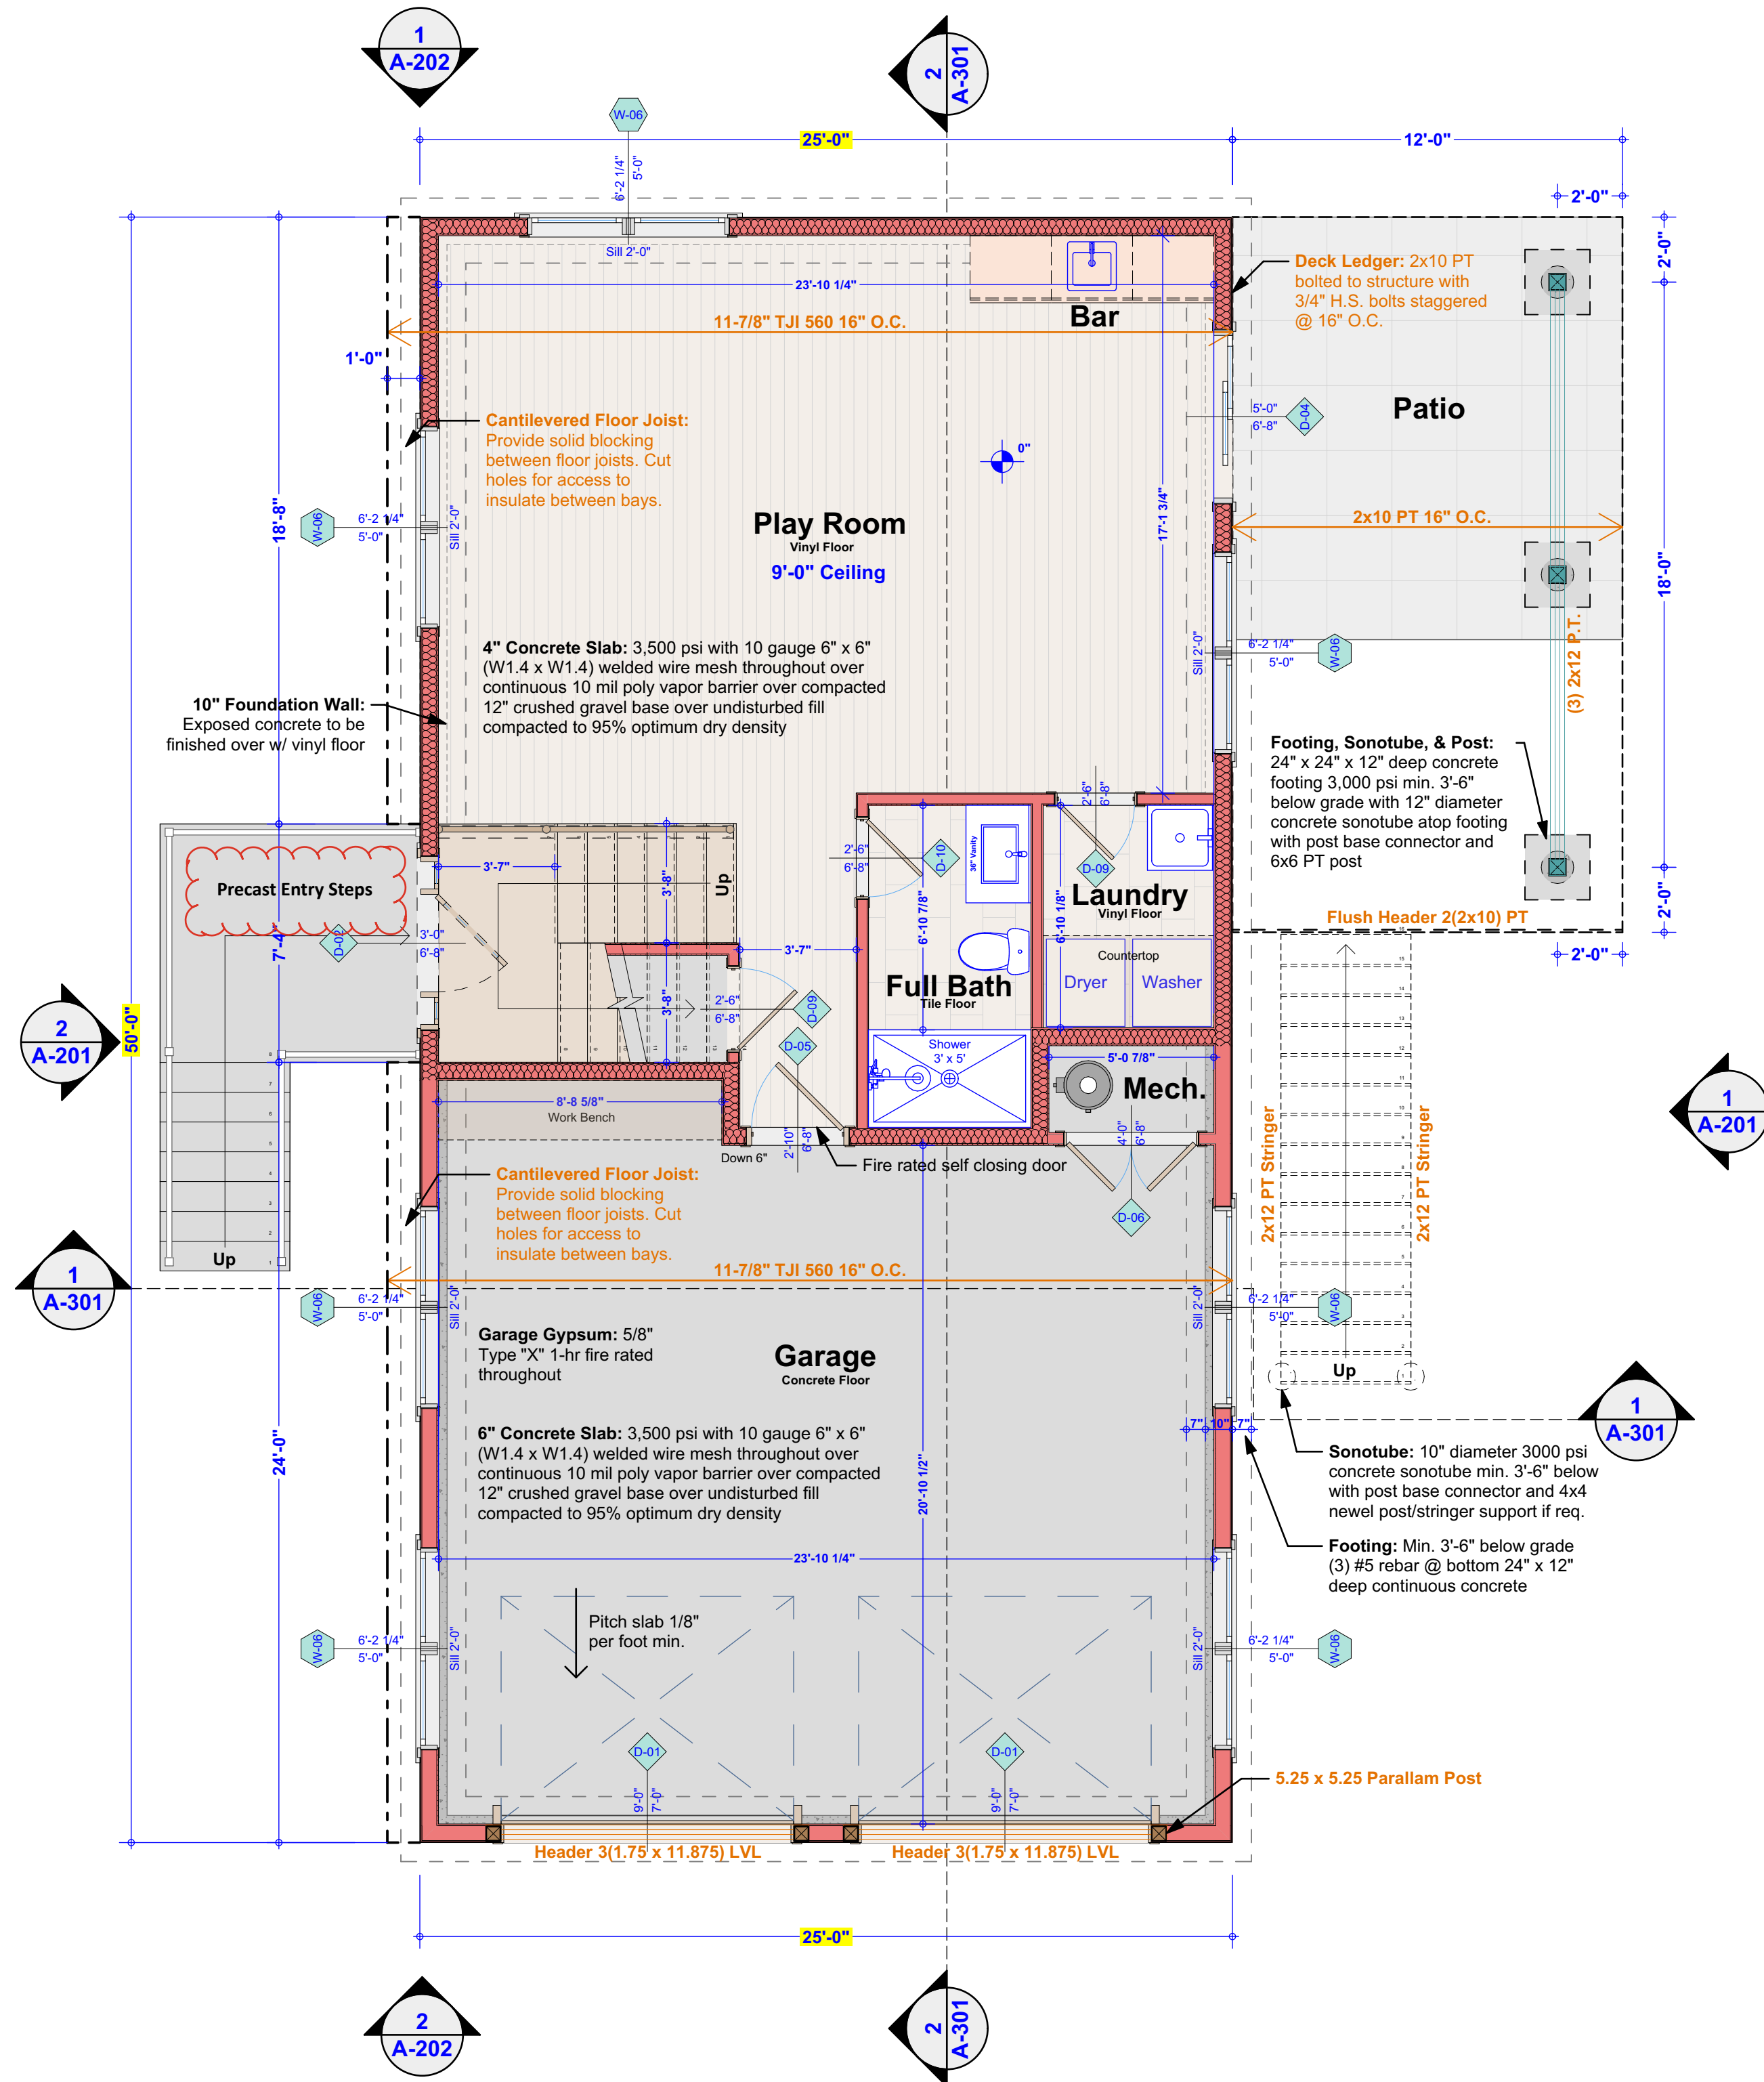OF 18



1 First Floor Plan

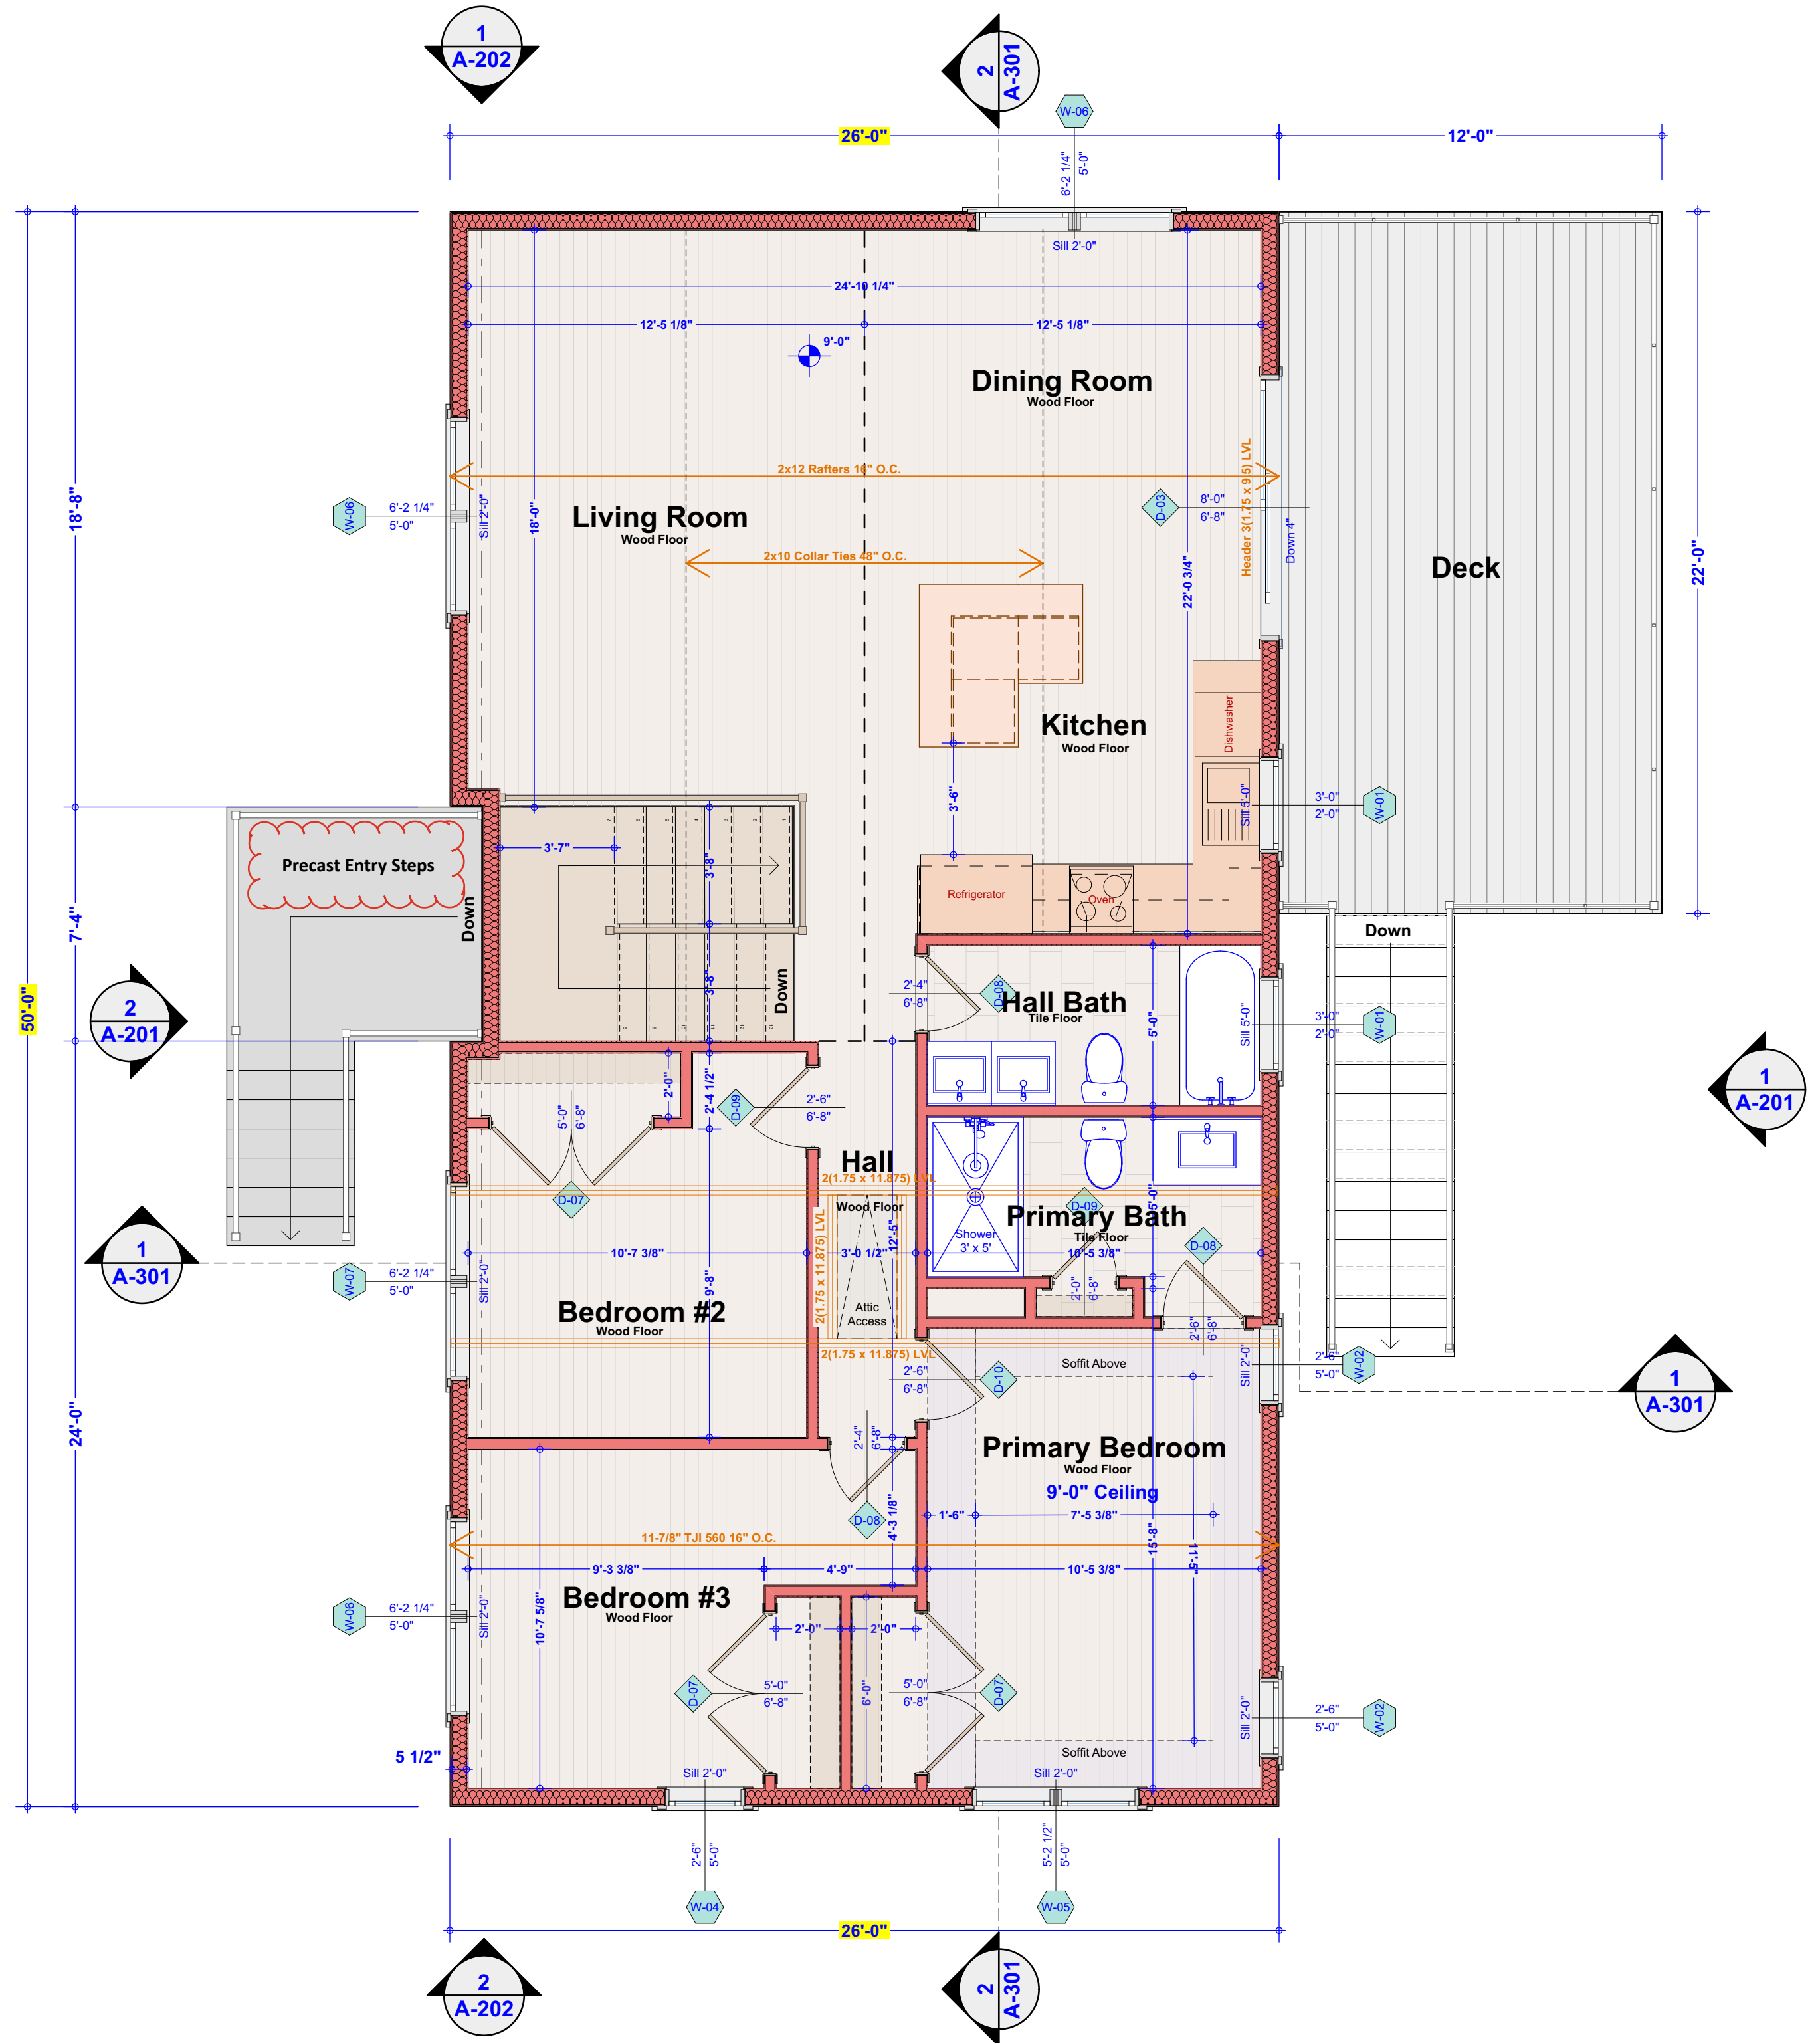 
SCALE: 1/4" = 1'-0"




2 Second Floor Plan

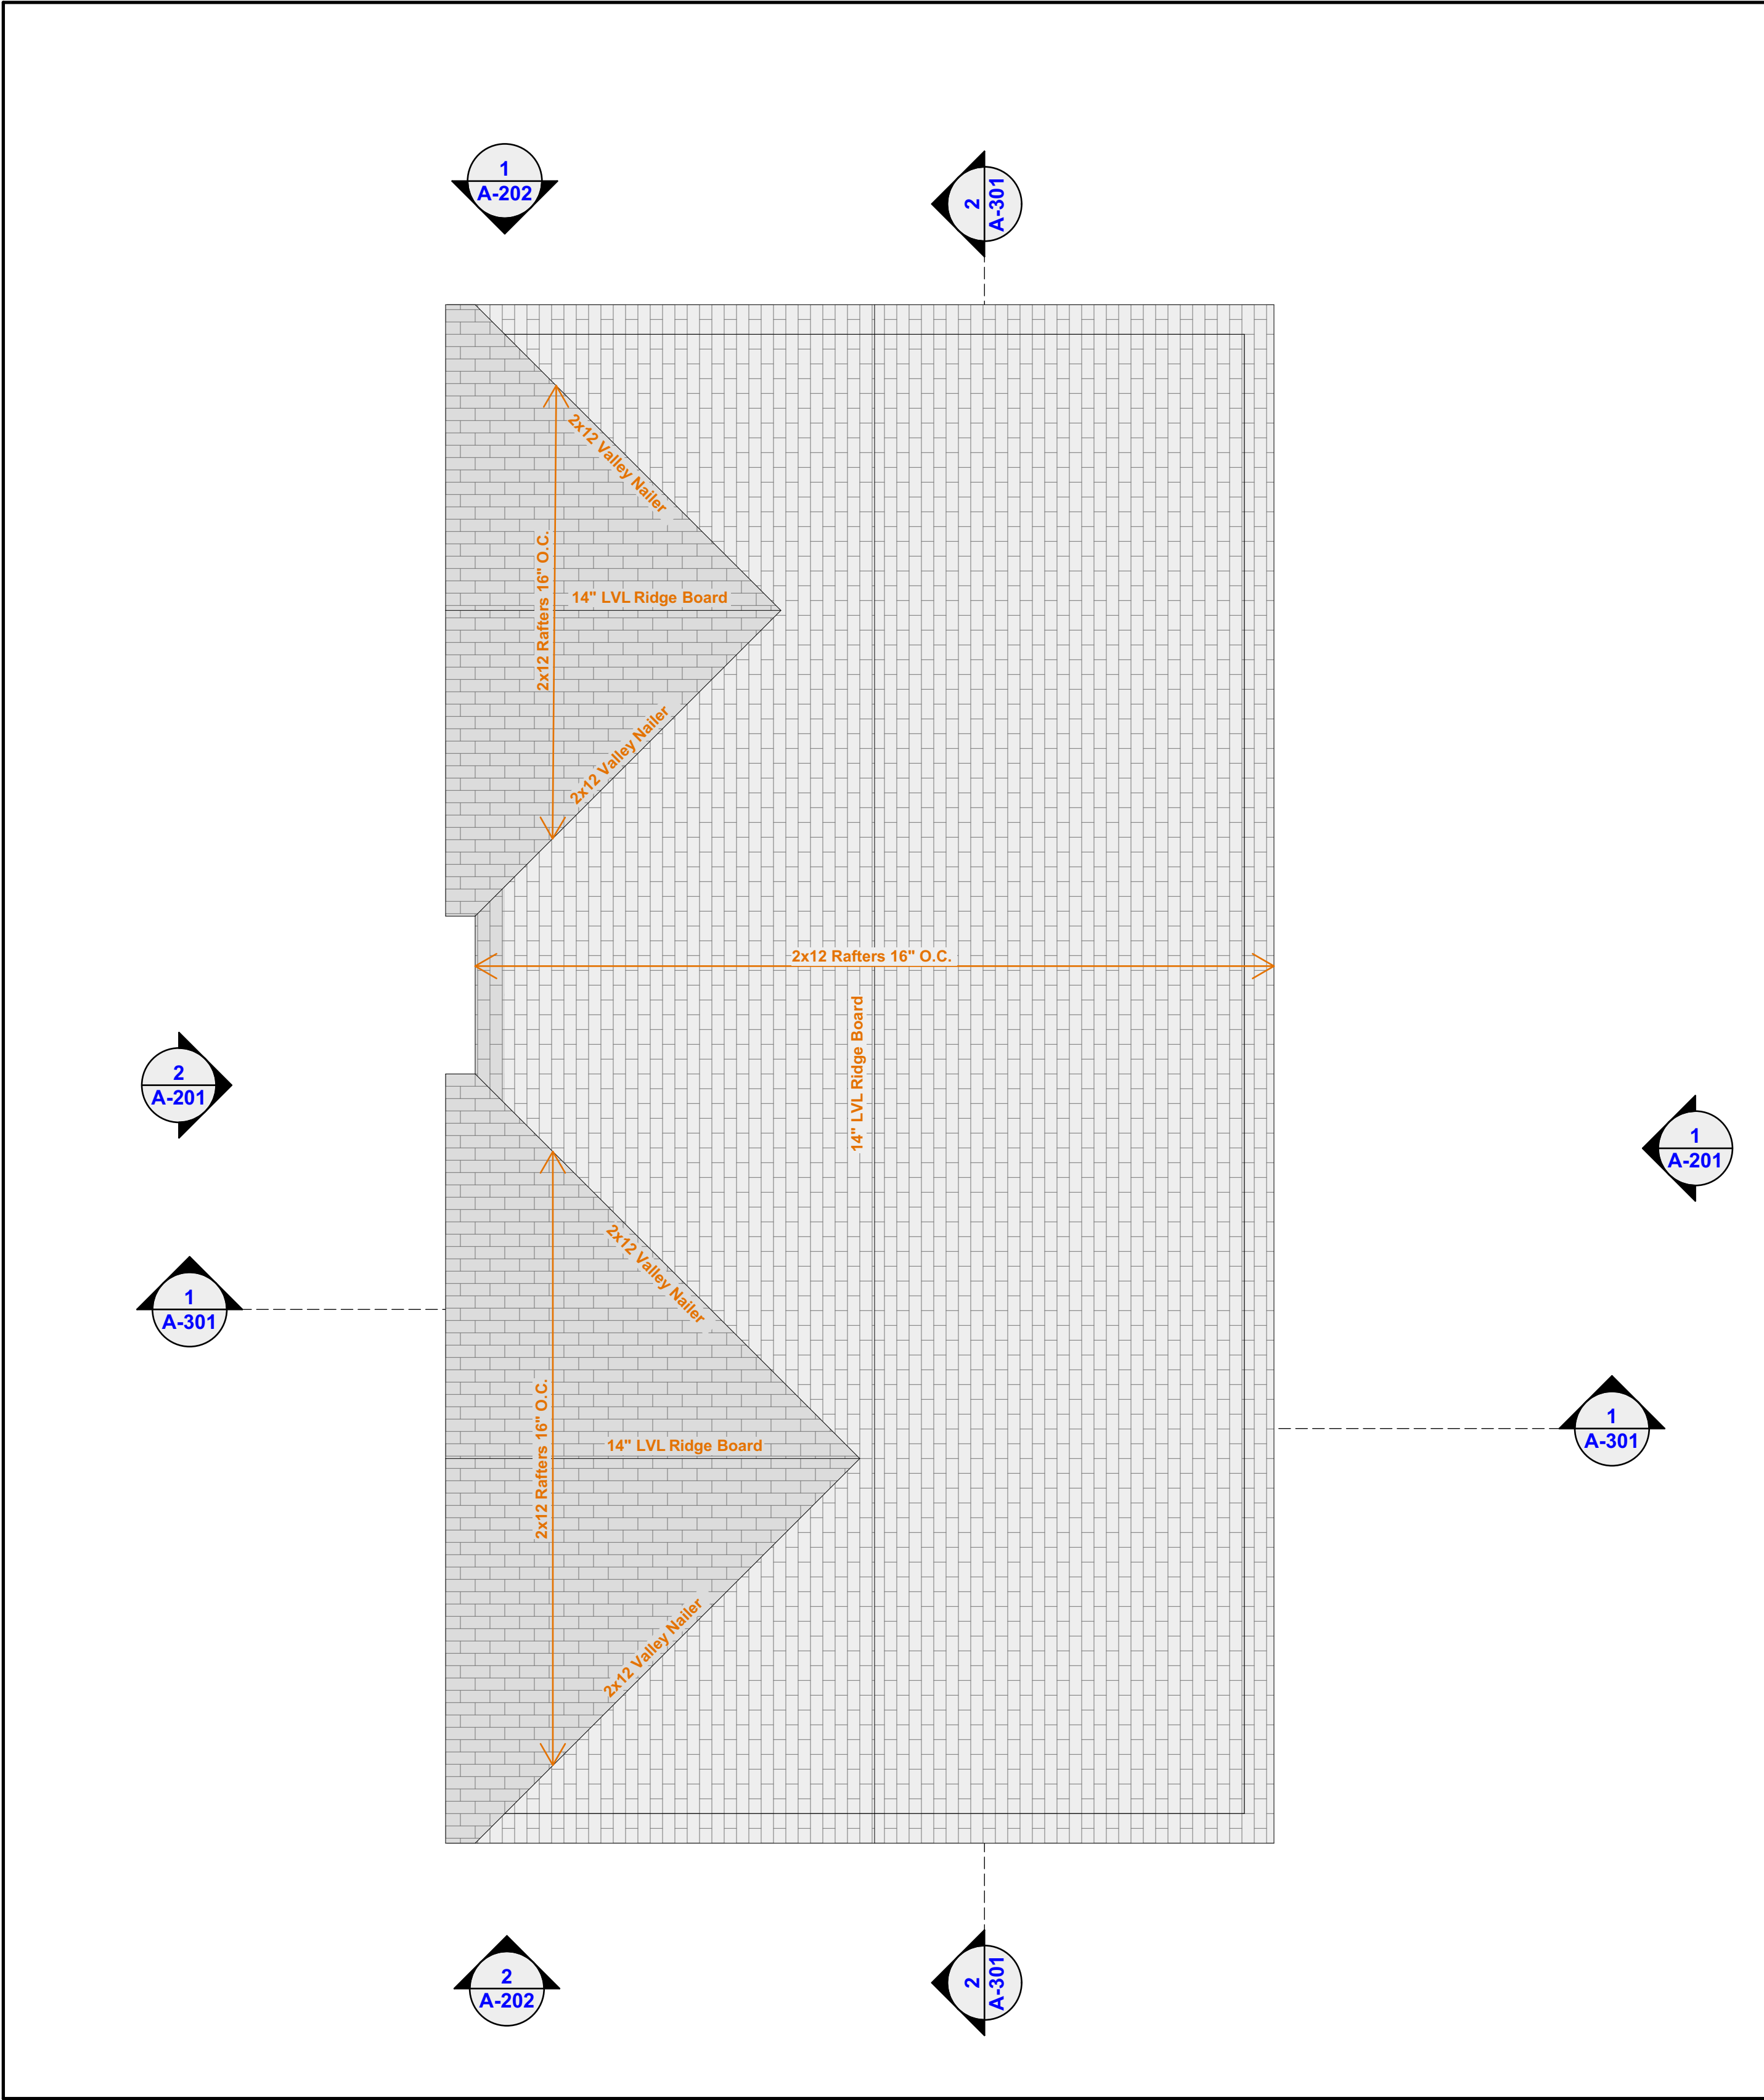SCALE: 1/4" = 1'-0"






1 Roof Plan
SCALE: 1/4" = 1'-0"

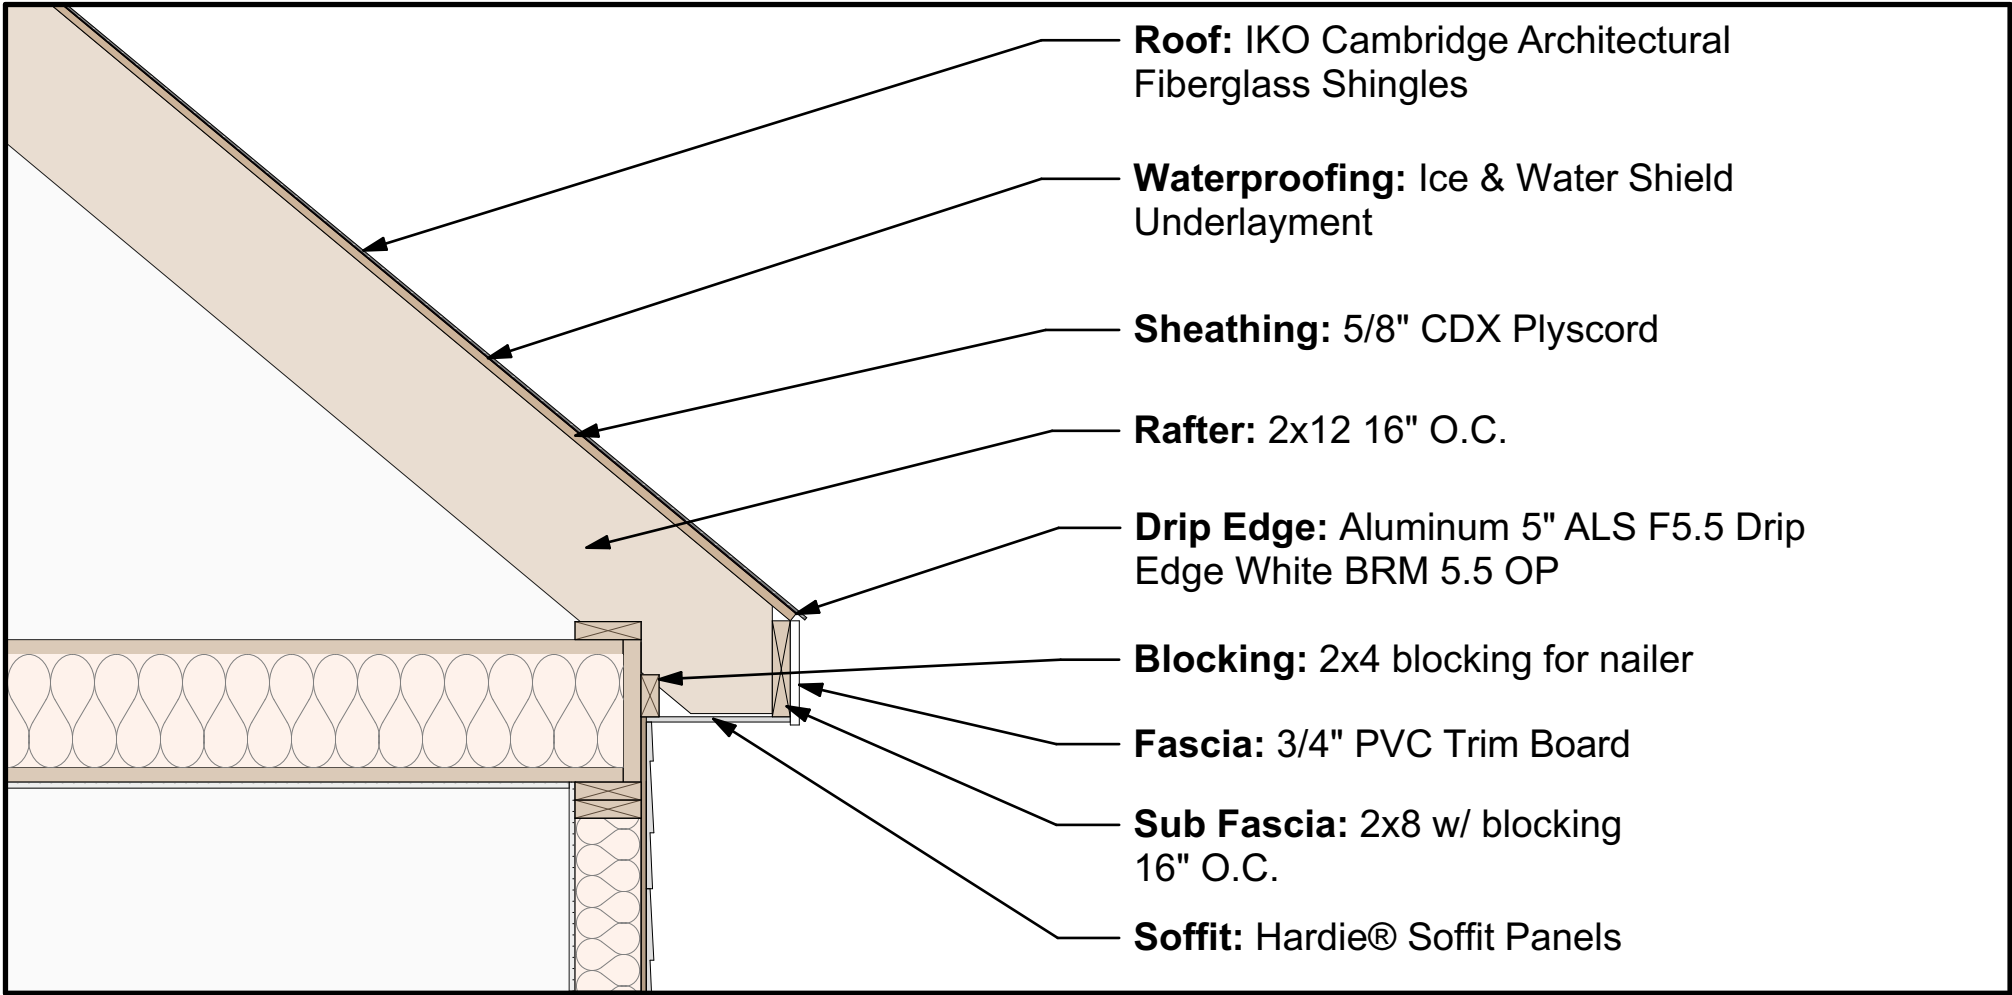

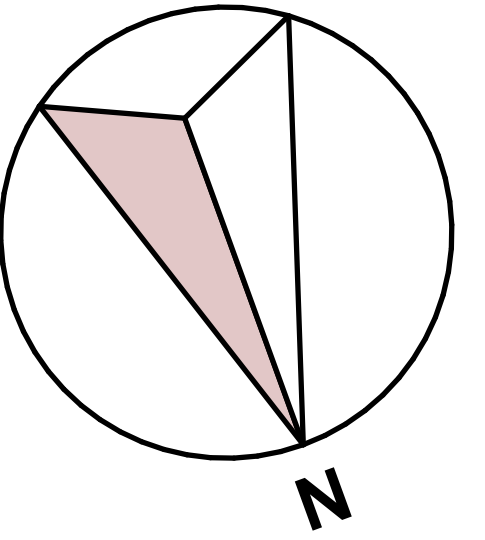2 Eave Soffit Detail
SCALE: 3/4" = 1'-0"



CONSULTANTS

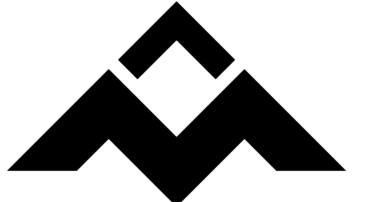


CARDINAL DESIGN

211 Greenwood Avenue
Bethel, CT 06801
United States
www.cardinalde.com
projects@cardinalde.com

Raised Ranch

4 Old Neversink Road
Danbury Connecticut 06811
United States



CASALI COMPANIES
BUILDING ON TRUST

211 Greenwood Avenue
Bethel, CT 06801
United States
www.casalicompanies.com
projects@casalicompanies.com

PROJECT NO: 1006

MODEL FILE:
4 Old Neversink Road.pln

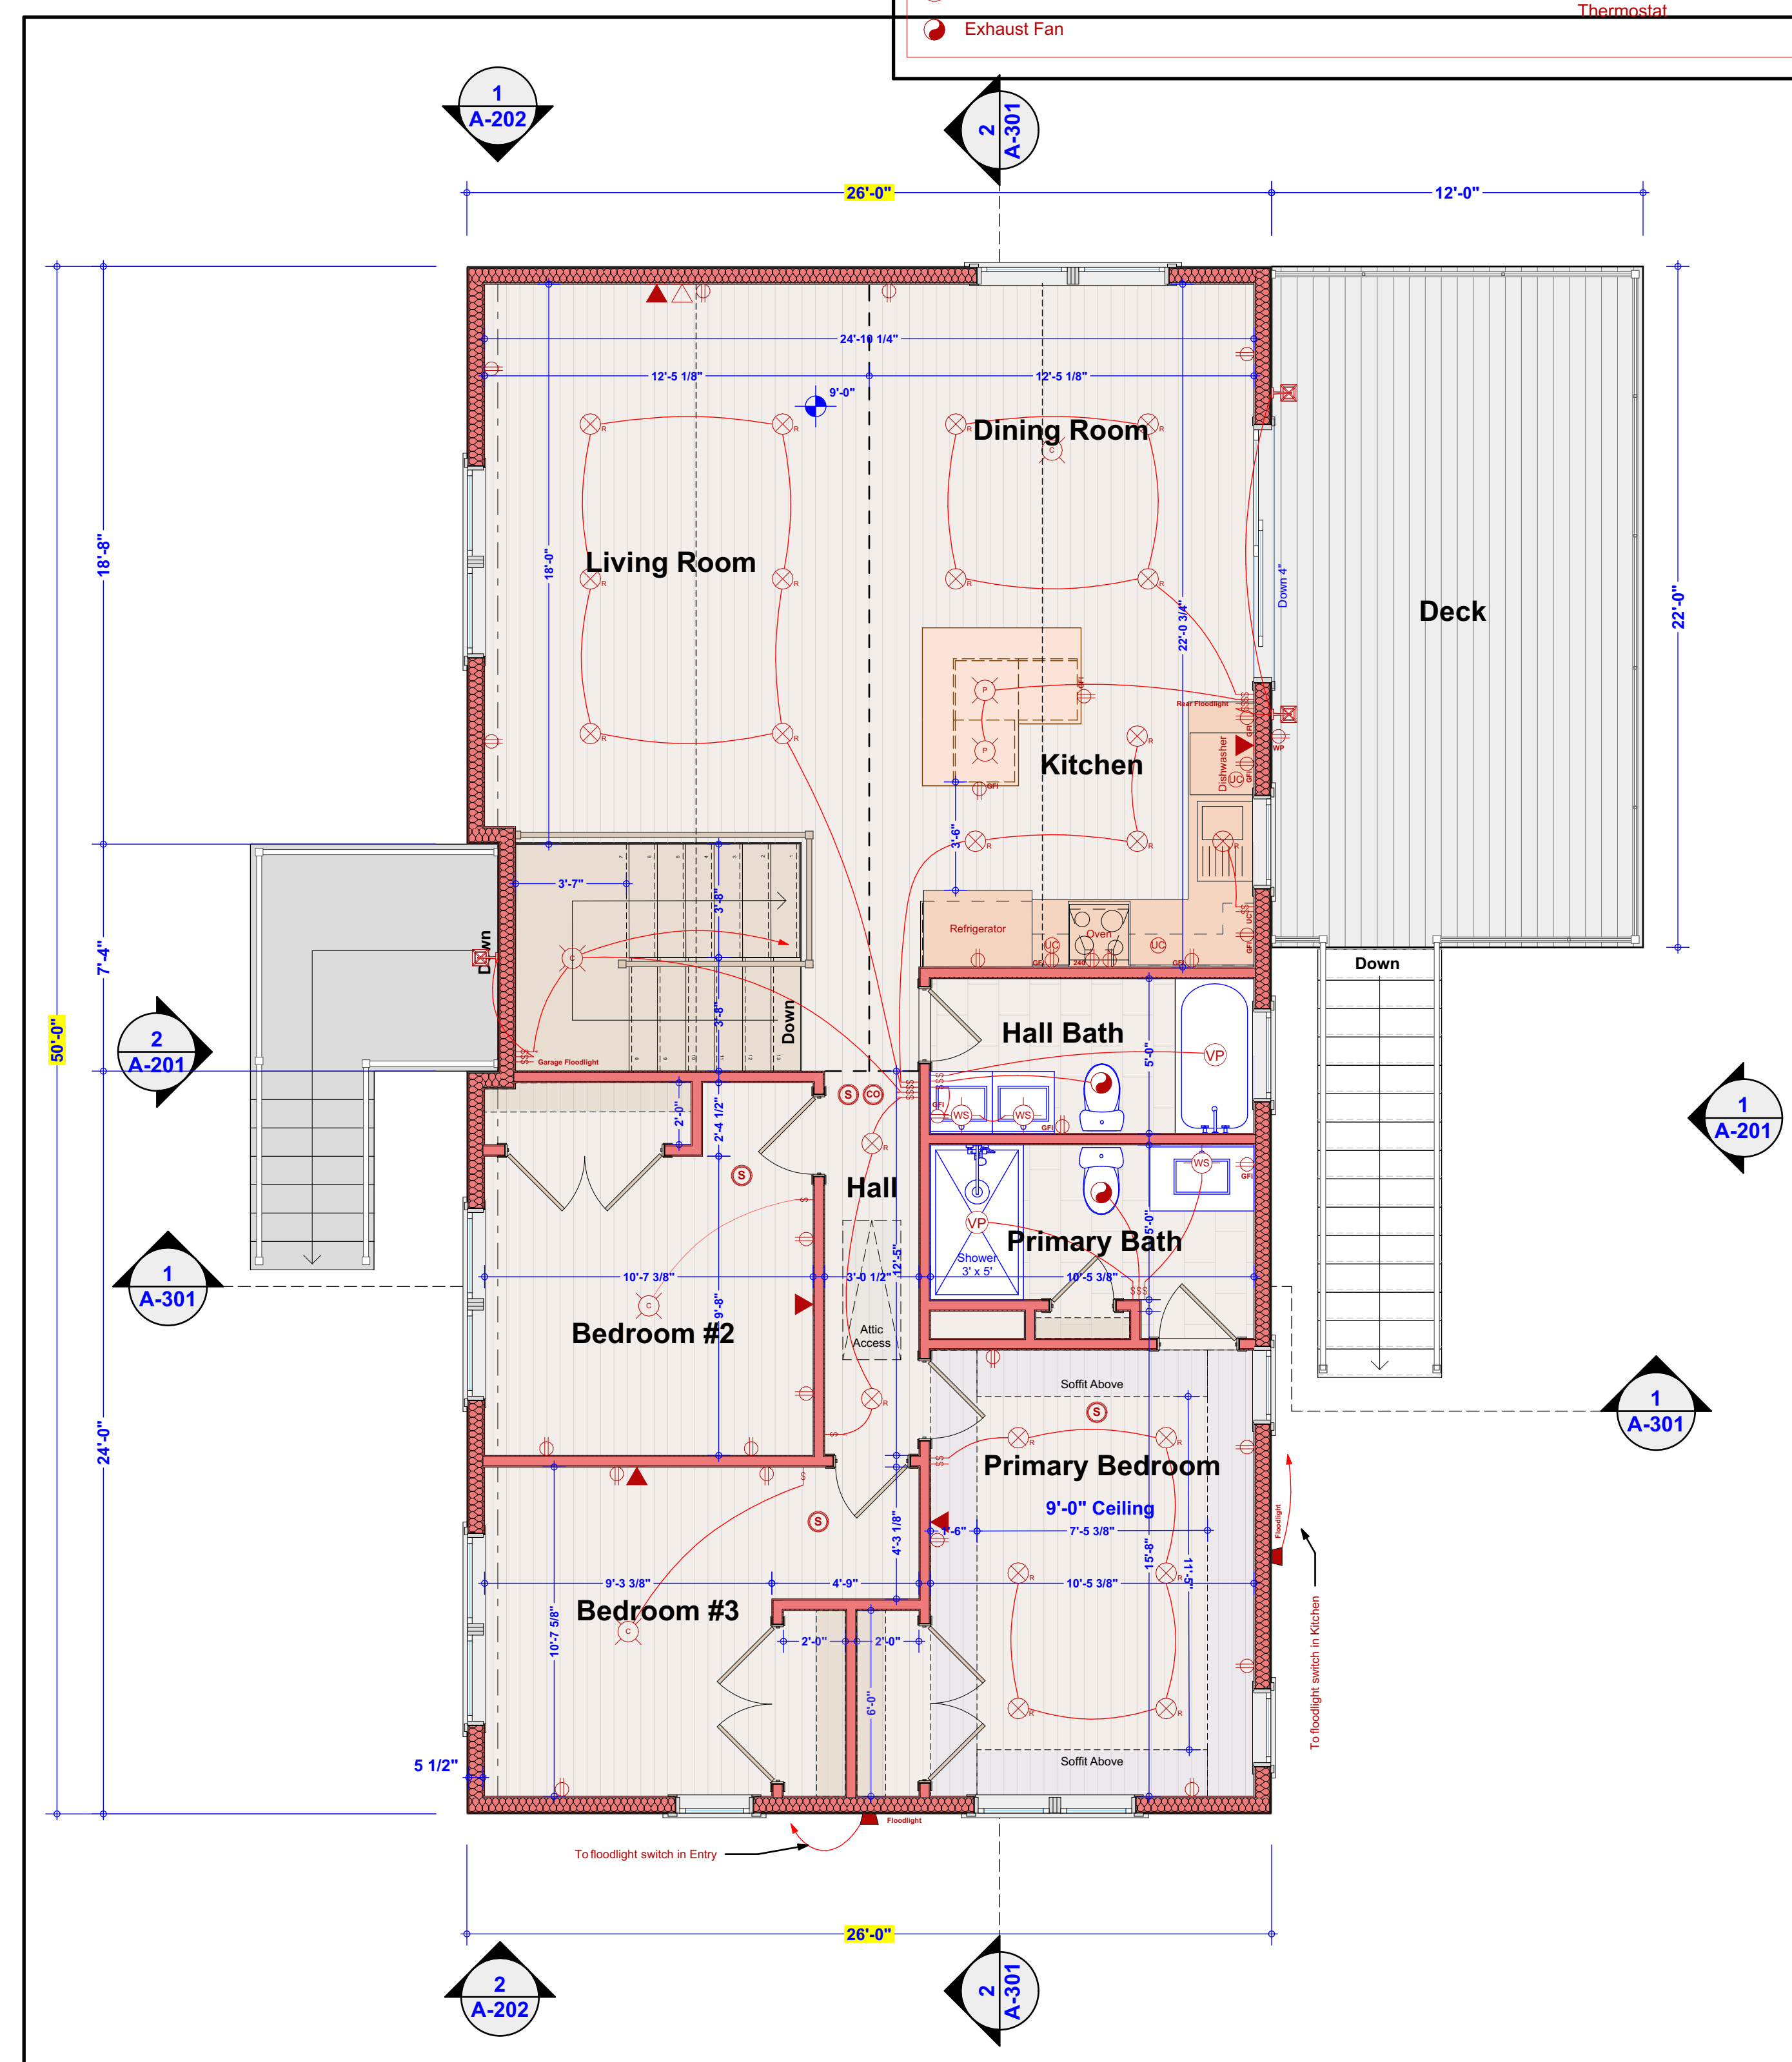
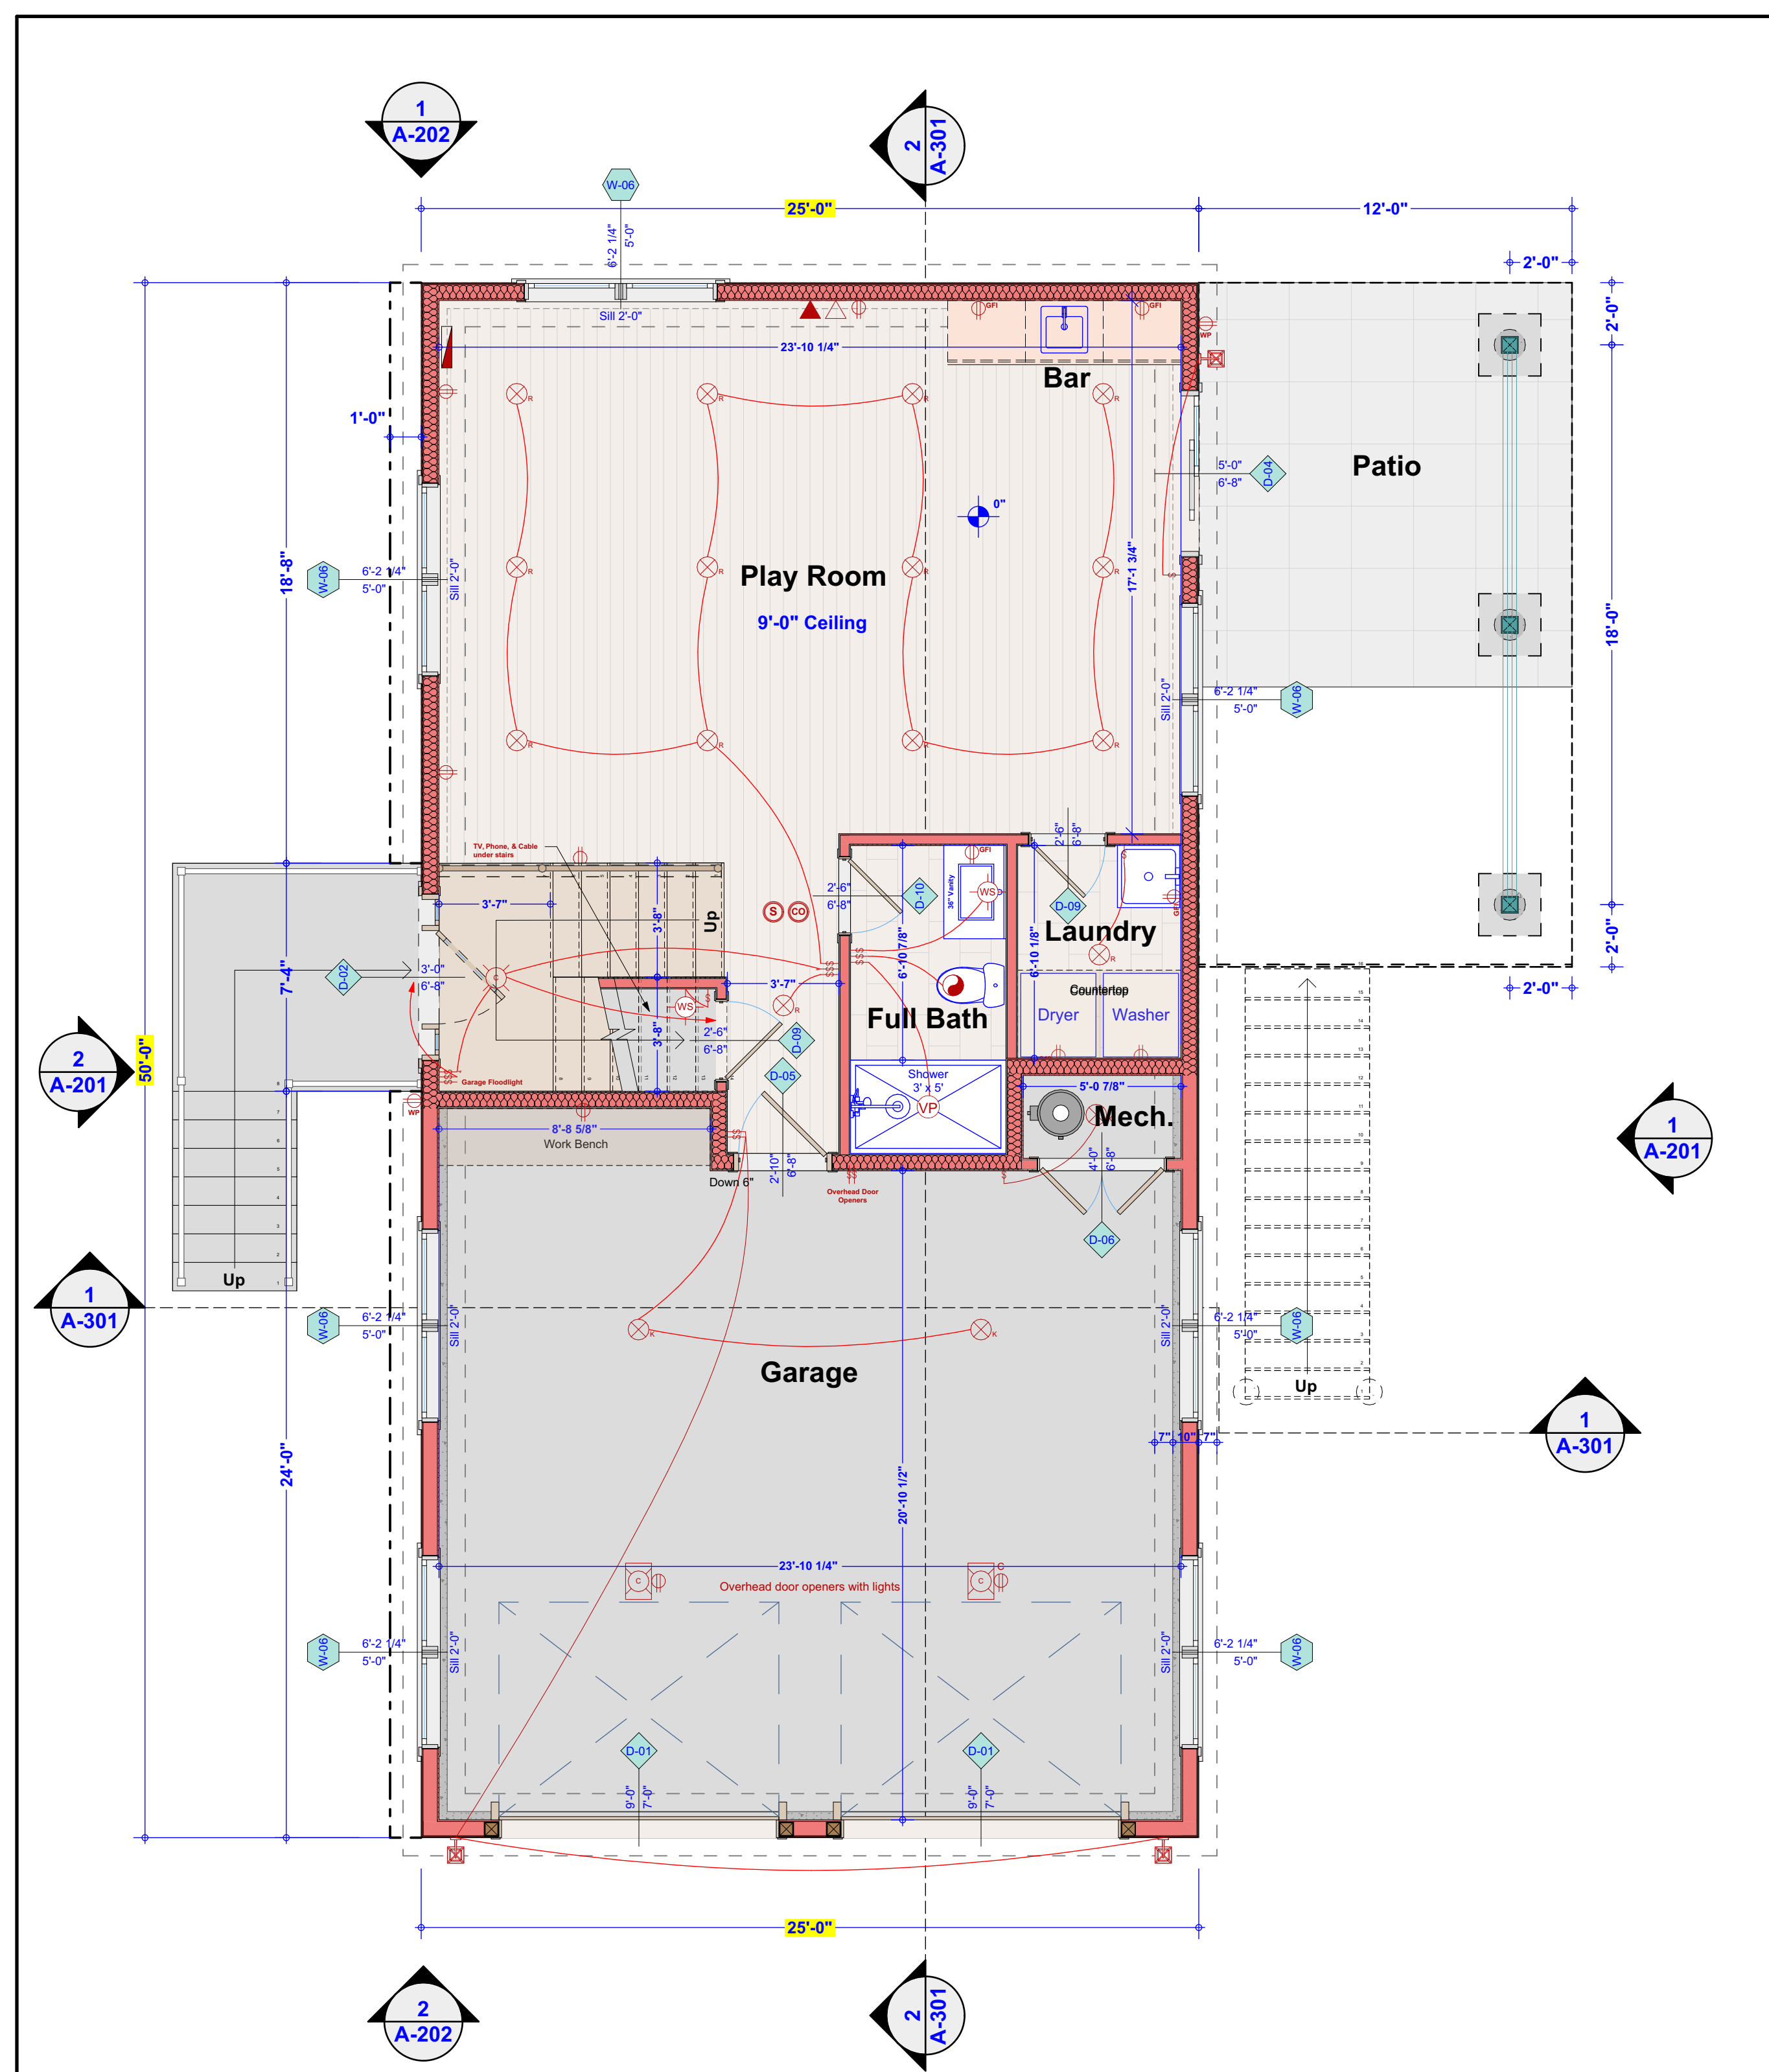
DRAWN BY: Jim Casali, Jr.

COPYRIGHT: 2025

SHEET TITLE

Roof Plan





	Smoke Detector		Coach Light		Garage Door Opener w/ Light
	Carbon Monoxide Detector		Wall Sconce		Electric Meter
	Coaxial Cable Jack		Vapor Proof Shower Light		Electric Panel
	Waterproof GFI Outlet		Ceiling Fixture		Recessed Ceiling Fixture
	120 Volt Duplex Outlet		Door Bell		Thermostat
	240 Volt Outlet		Door Bell Button		
	Undercabinet Strip Light				
	Exhaust Fan				

CONSULTANTS



CARDINAL DESIGN

211 Greenwood Avenue
Bethel, CT 06801
United States
www.cardinalde.com
projects@cardinalde.com

Raised Ranch

**4 Old Neversink Road
Danbury Connecticut 06811
United States**



CASALI COMPANIES
BUILDING ON TRUST

211 Greenwood Avenue
Bethel, CT 06801
United States
www.casalicompanies.com
projects@casalicompanies.com

PROJECT NO: 1006

MODEL FILE:

4 Old Neversink Road.pln

DRAWN BY: Jim Casali, Jr.

COPYRIGHT: 2025

SHEET TITLE

Electrical Plans

4

A-103

OF 18



2 West Elevation
SCALE: 1/4" = 1'-0"



1 East Elevation
SCALE: 1/4" = 1'-0"

CONSULTANTS



CARDINAL DESIGN

211 Greenwood Avenue
Bethel, CT 06801
United States
www.cardinalde.com
projects@cardinalde.com

Raised Ranch

4 Old Neversink Road
Danbury Connecticut 06811
United States



CASALI COMPANIES
BUILDING ON TRUST

211 Greenwood Avenue
Bethel, CT 06801
United States
www.casalicompanies.com
projects@casalicompanies.com

PROJECT NO: 1006

MODEL FILE:

4 Old Neversink Road.pln

DRAWN BY: Jim Casali, Jr.

COPYRIGHT: 2025

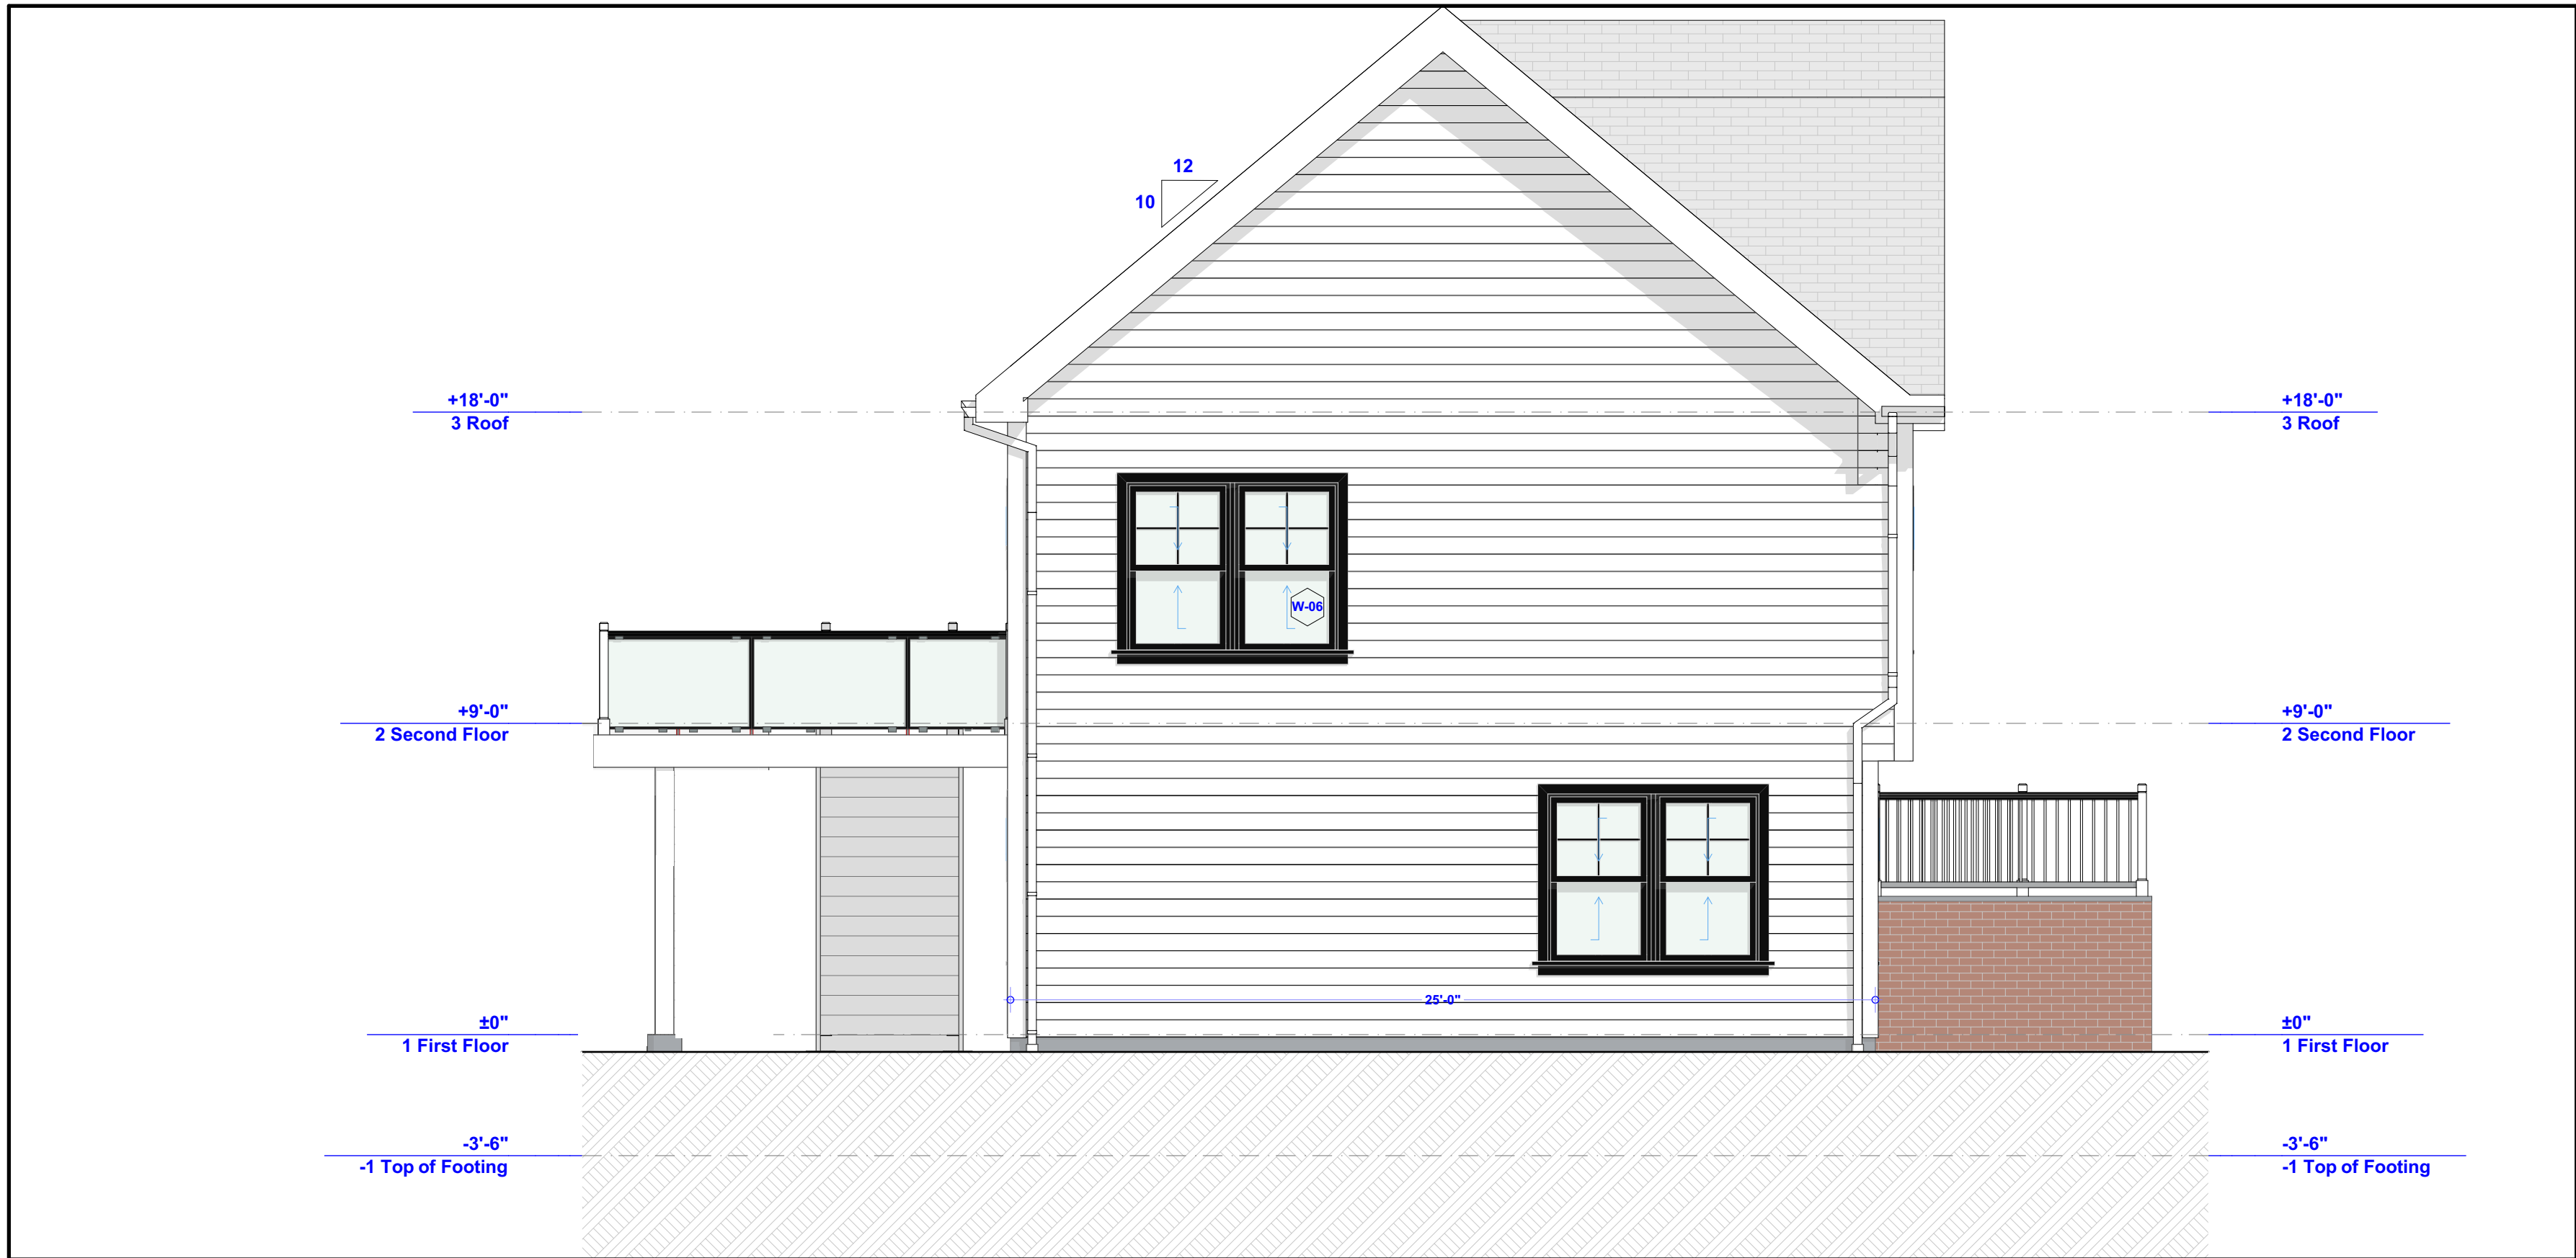
SHEET TITLE

East & West Elevation

5



2 South Elevation
SCALE: 1/4" = 1'-0"



1 North Elevation
SCALE: 1/4" = 1'-0"

CONSULTANTS

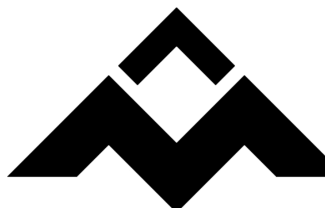


CARDINAL DESIGN

211 Greenwood Avenue
Bethel, CT 06801
United States
www.cardinalde.com
projects@cardinalde.com

Raised Ranch

4 Old Neversink Road
Danbury Connecticut 06811
United States



CASALI COMPANIES
BUILDING ON TRUST

211 Greenwood Avenue
Bethel, CT 06801
United States
www.casalicompanies.com
projects@casalicompanies.com

PROJECT NO: 1006

MODEL FILE:

4 Old Neversink Road.pln

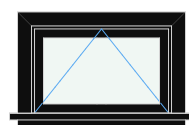
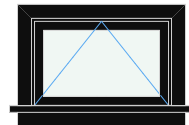
 
 
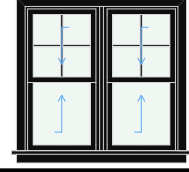
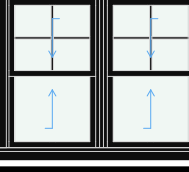
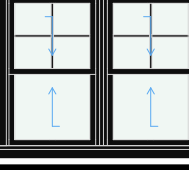
DRAWN BY: Jim Casali, Jr.













COPYRIGHT: 2025

SHEET TITLE

North & South Elevation

6

Window Schedule									
Mark	Model	Quantity	Rough Opening	Unit Dimensions	Tempered	Jamb Size	U-Factor	Exterior Elevation	Egress
W-01	Harvey Classic	1	3'-0"×2'-0"	3'-0"×2'-0"	☐	6-9/16"	.27		No
W-01	Harvey Classic	1	3'-0"×2'-0"	3'-0"×2'-0"	☒	6-9/16"	.27		No
W-02	Harvey Classic	2	2'-6"×5'-0"	2'-6"×5'-0"	☐	6-9/16"	.27		No
W-04	Harvey Classic	1	2'-6"×5'-0"	2'-6"×5'-0"	☒	6-9/16"	.27		No
W-05	Harvey Classic	1	5'-2 1/2"×5'-0"	5'-2 1/2"×5'-0"	☒	6-9/16"	.27		No
W-06	Harvey Classic	10	6'-2 1/4"×5'-0"	6'-2 1/4"×5'-0"	☐	6-9/16"	.27		Yes
W-07	Harvey Classic	1	6'-2 1/4"×5'-0"	6'-2 1/4"×5'-0"	☒	6-9/16"	.27		Yes

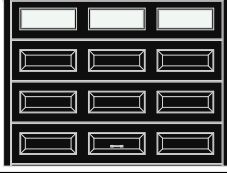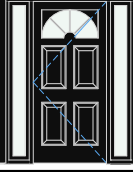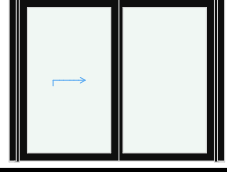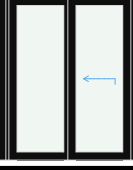 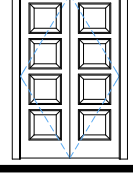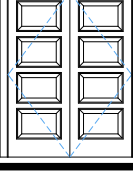     DOOR SCHEDULE						
Mark	Frame Size	Quantity	Type	Jamb Size	Notes	Elevation View
D-01	9'-0"×7'-0"	2	Overhead Automatic	Undefined	Undefined	
D-02	3'-0"×6'-8"	1	Entry Door	6-9/16"	Undefined	
D-03	8'-0"×6'-8"	1	Sliding Door	6-9/16"	Undefined	
D-04	5'-0"×6'-8"	1	Sliding Door	6-9/16"	Undefined	
D-05	2'-10"×6'-8"	1	Interior Shaker Fire Door	6-9/16"	Trimlite 4-Panel Shaker Interior Prehung Fire Rated Passage Door with Oil Rubbed Bronze Hinges and Mill Sill	
D-06	4'-0"×6'-8"	1	Interior Shaker Double Door	4-9/16"	Trimlite Shaker 4-Panel Interior Pre-Hung Passage Double Door with Oil Rubbed Bronze Hinges	
D-07	5'-0"×6'-8"	3	Interior Shaker Double Door	4-9/16"	Trimlite Shaker 4-Panel Interior Pre-Hung Passage Double Door with Oil Rubbed Bronze Hinges	
D-08	2'-4"×6'-8"	2	Interior Shaker Door	4-9/16"	Trimlite Shaker 4-Panel Interior Pre-Hung Passage Door with Oil Rubbed Bronze Hinges	
D-08	2'-6"×6'-8"	1	Interior Shaker Door	4-9/16"	Trimlite Shaker 4-Panel Interior Pre-Hung Passage Door with Oil Rubbed Bronze Hinges	
D-09	2'-0"×6'-8"	1	Interior Shaker Door	4-9/16"	Trimlite Shaker 4-Panel Interior Pre-Hung Passage Door with Oil Rubbed Bronze Hinges	
D-09	2'-6"×6'-8"	3	Interior Shaker Door	4-9/16"	Trimlite Shaker 4-Panel Interior Pre-Hung Passage Door with Oil Rubbed Bronze Hinges	
D-10	2'-6"×6'-8"	2	Interior Shaker Door	4-9/16"	Trimlite Shaker 4-Panel Interior Pre-Hung Passage Door with Oil Rubbed Bronze Hinges	



CARDINAL DESIGN

211 Greenwood Avenue
Bethel, CT 06801
United States
www.cardinalde.com
projects@cardinalde.com

Raised Ranch

4 Old Neversink Road
Danbury Connecticut 06811
United States



CASALI COMPANIES
BUILDING ON TRUST

211 Greenwood Avenue
Bethel, CT 06801
United States
www.casalicompanies.com
projects@casalicompanies.com

PROJECT NO: 1006

MODEL FILE:
4 Old Neversink Road.pln

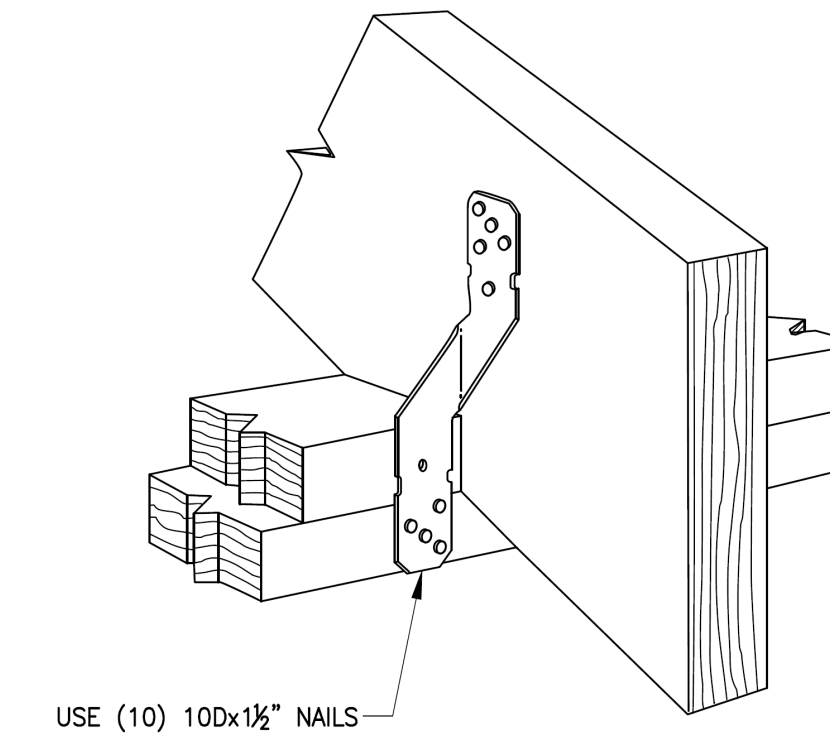
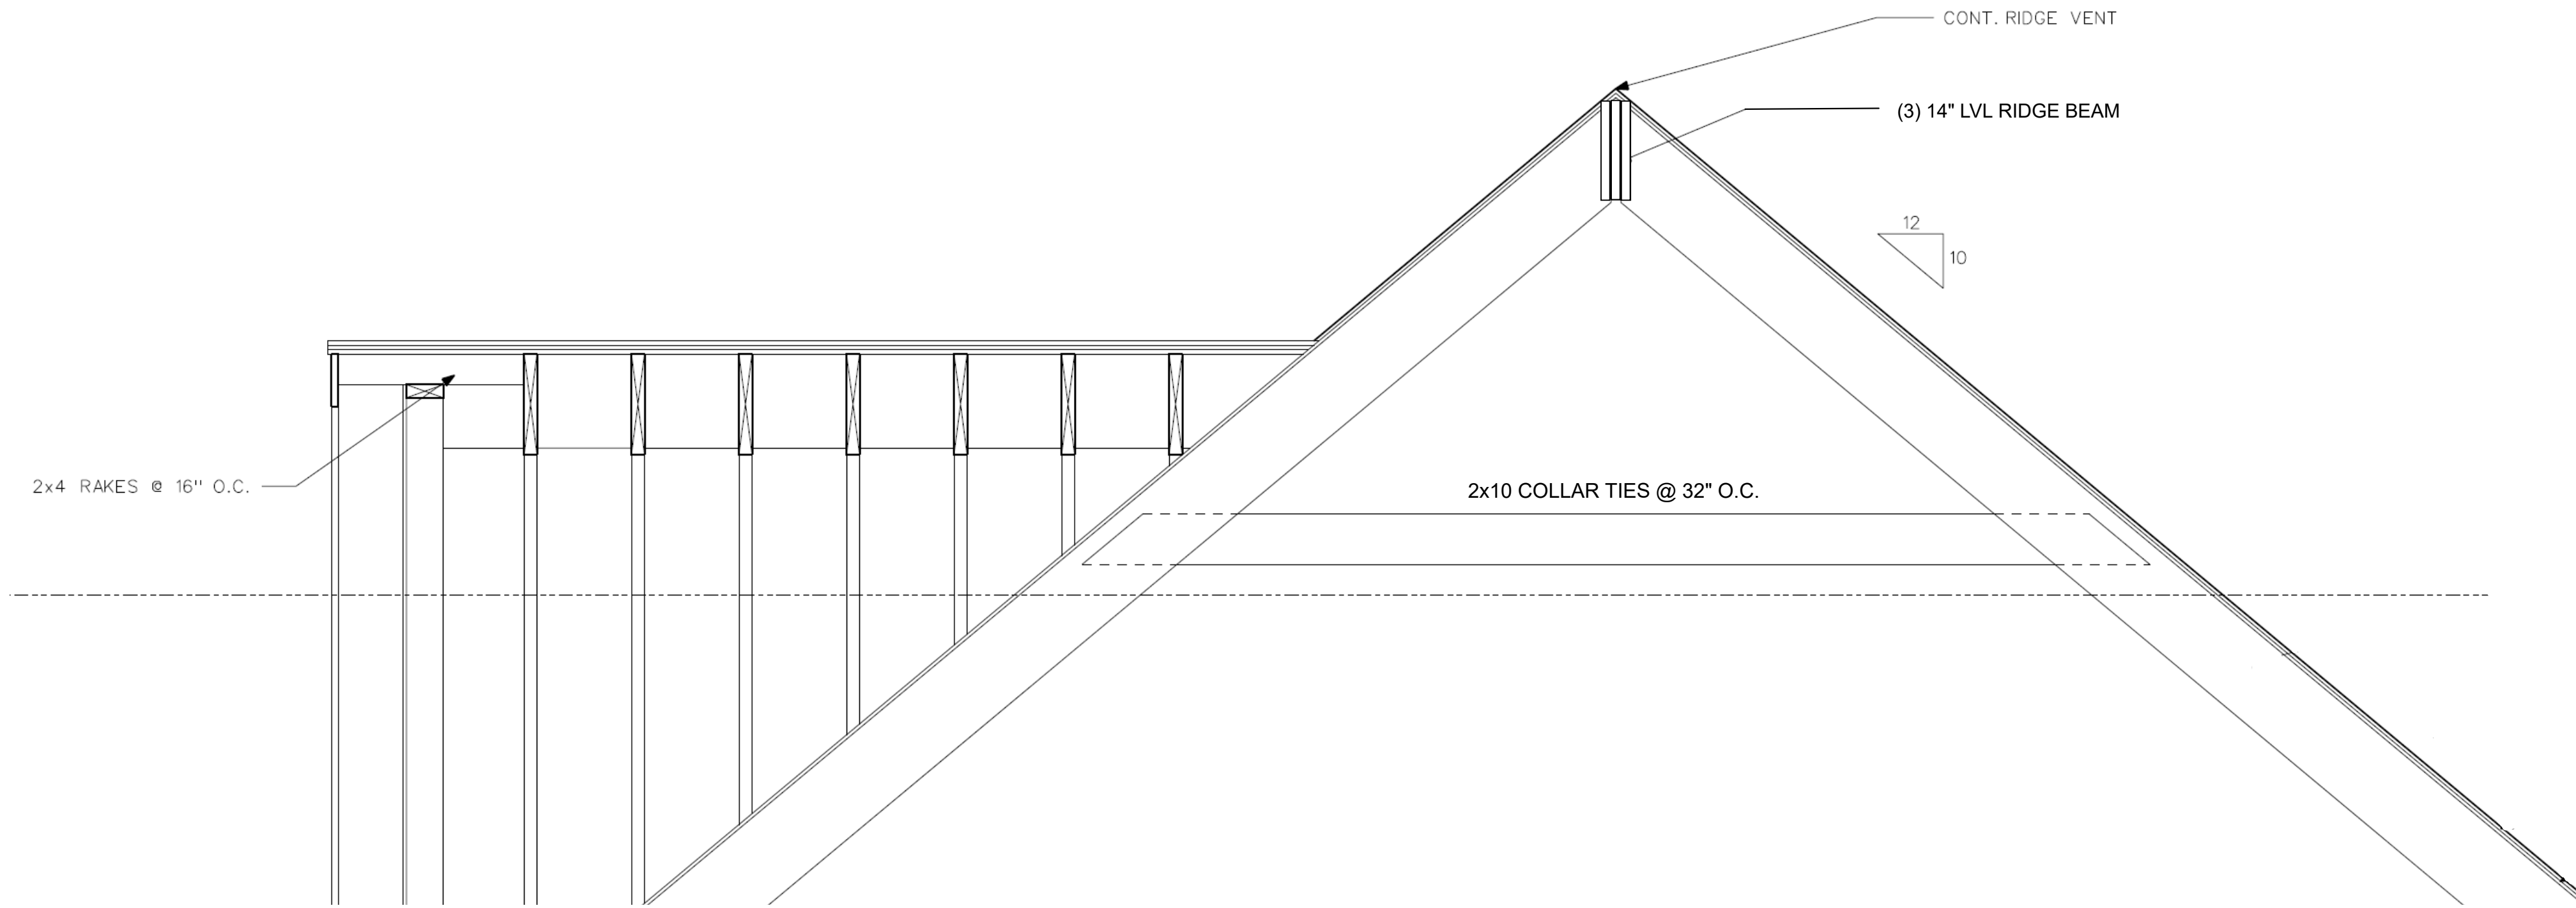
DRAWN BY: Jim Casali, Jr.

COPYRIGHT: 2025

SHEET TITLE


Openings Schedule






1 RAFTER TO TOP PLATES

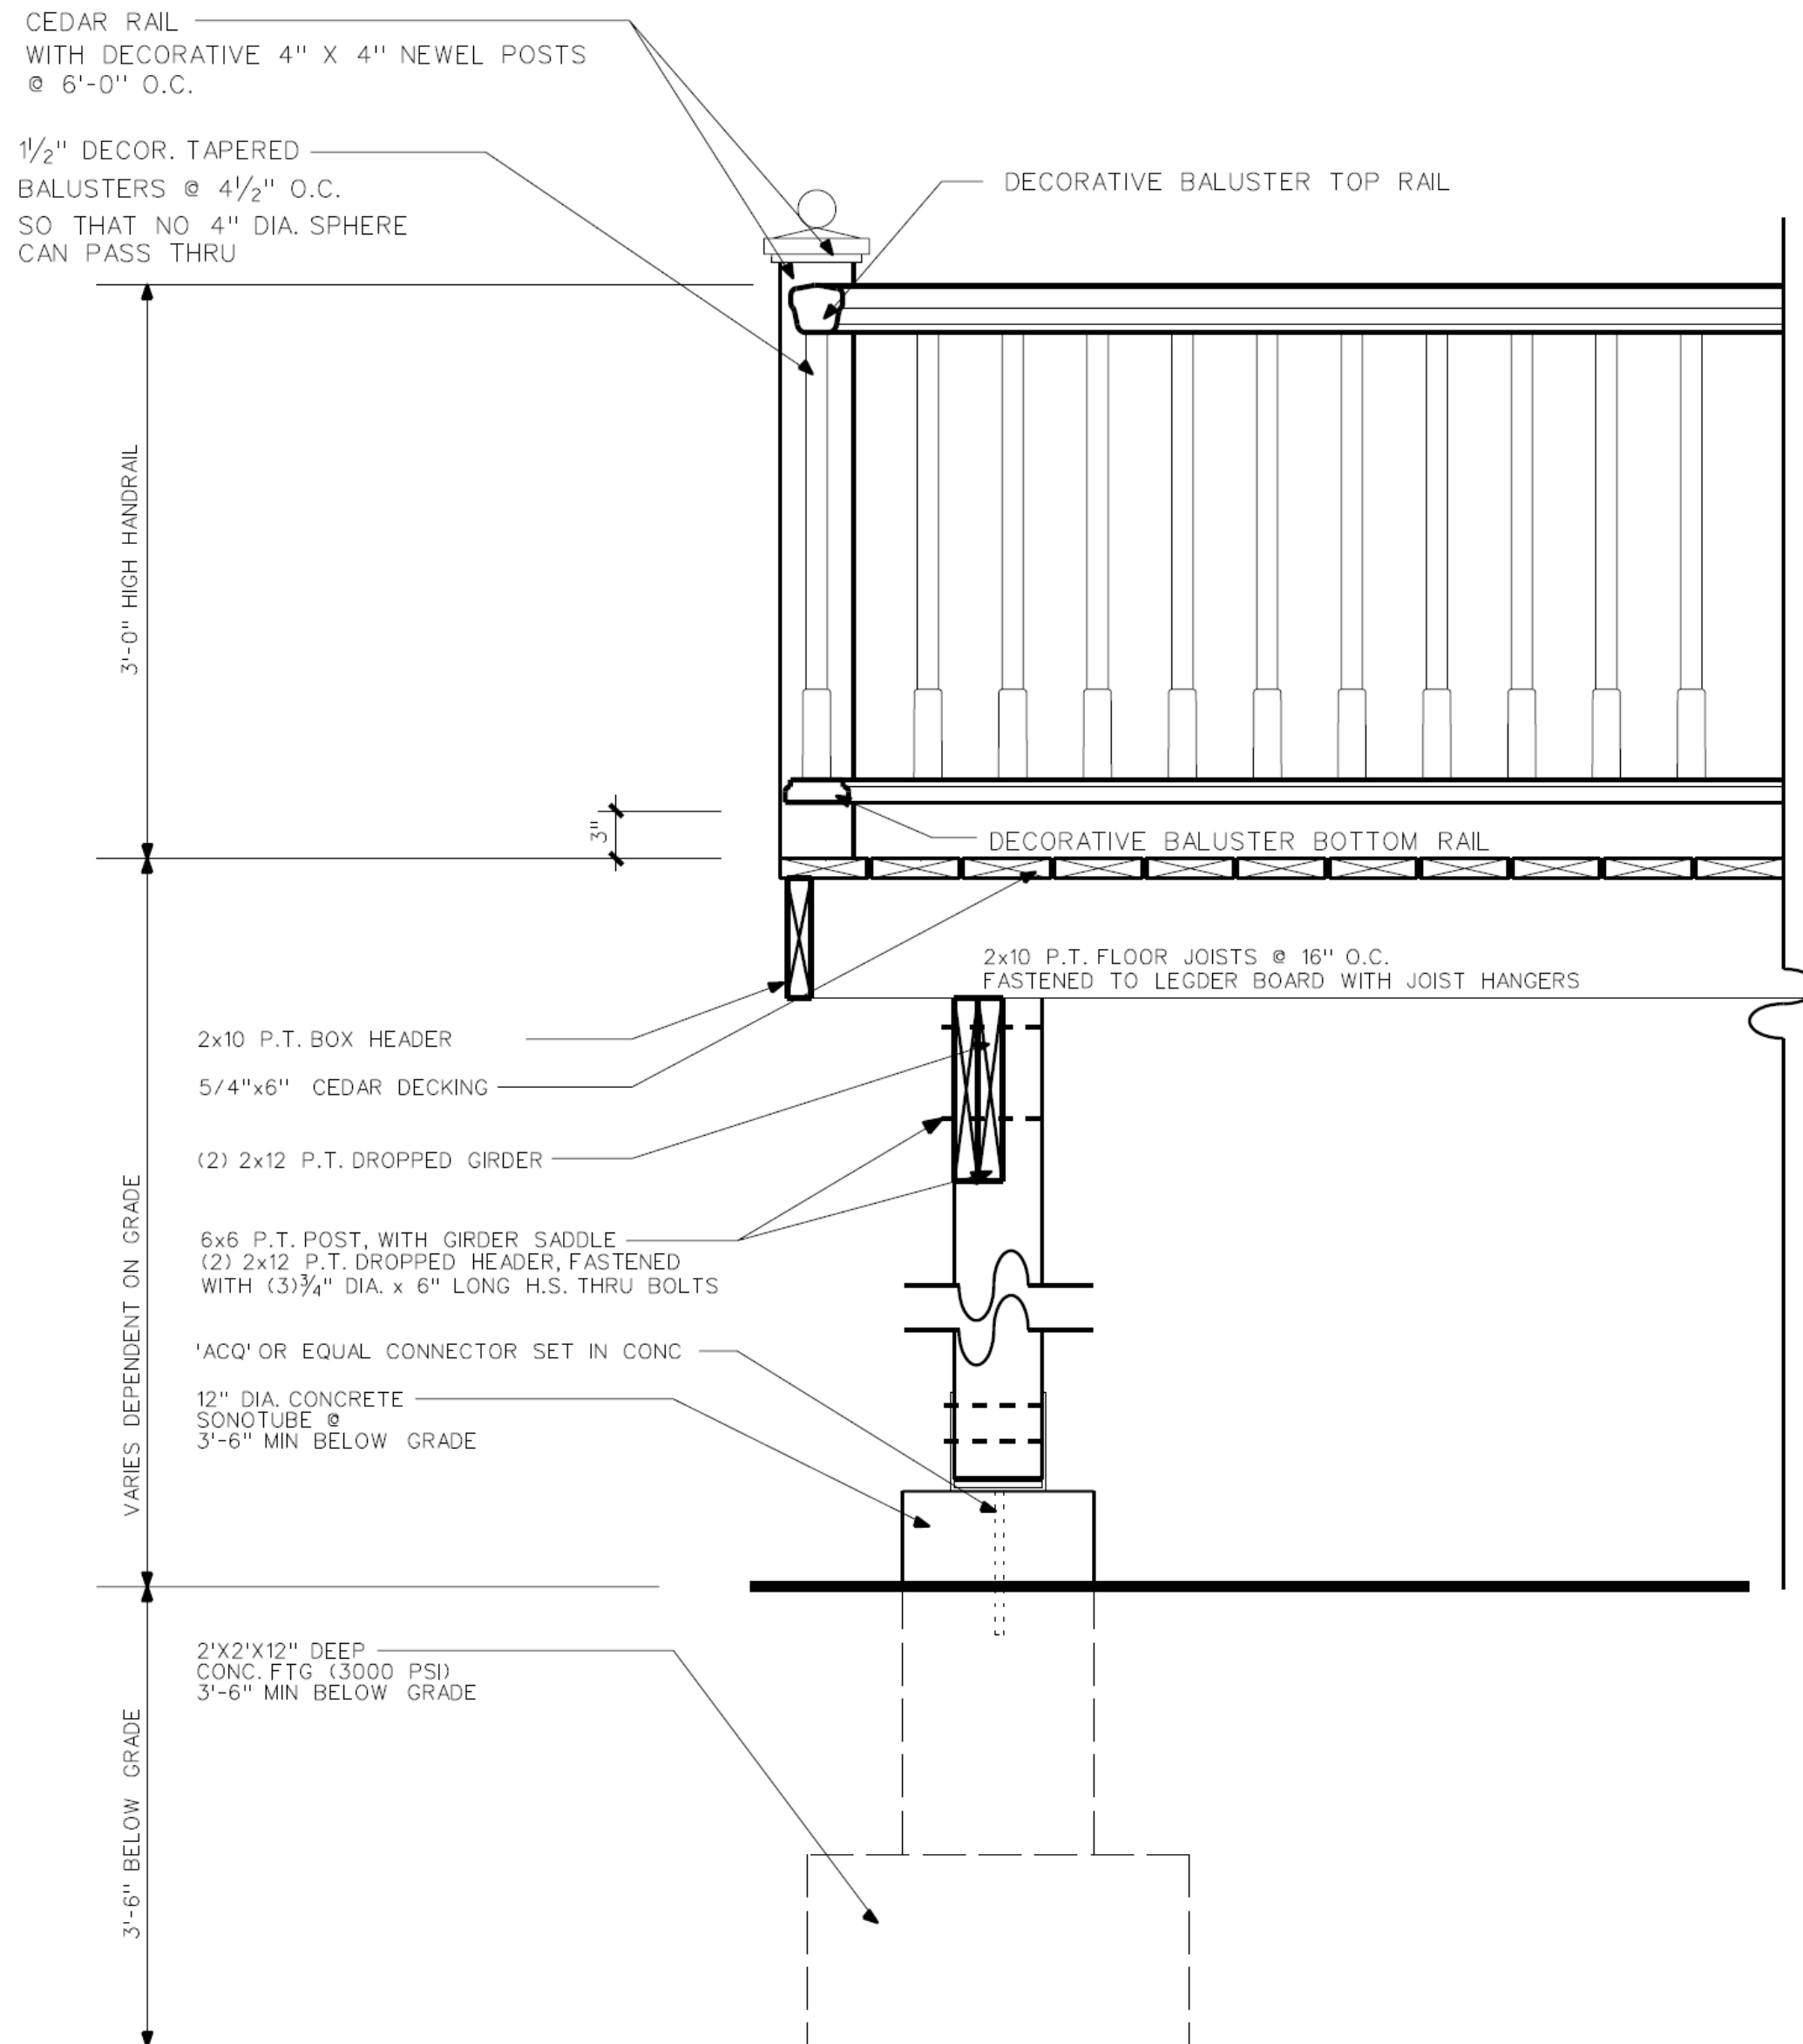NOT TO SCALE



3 SECTION & DETAIL THRU DECK

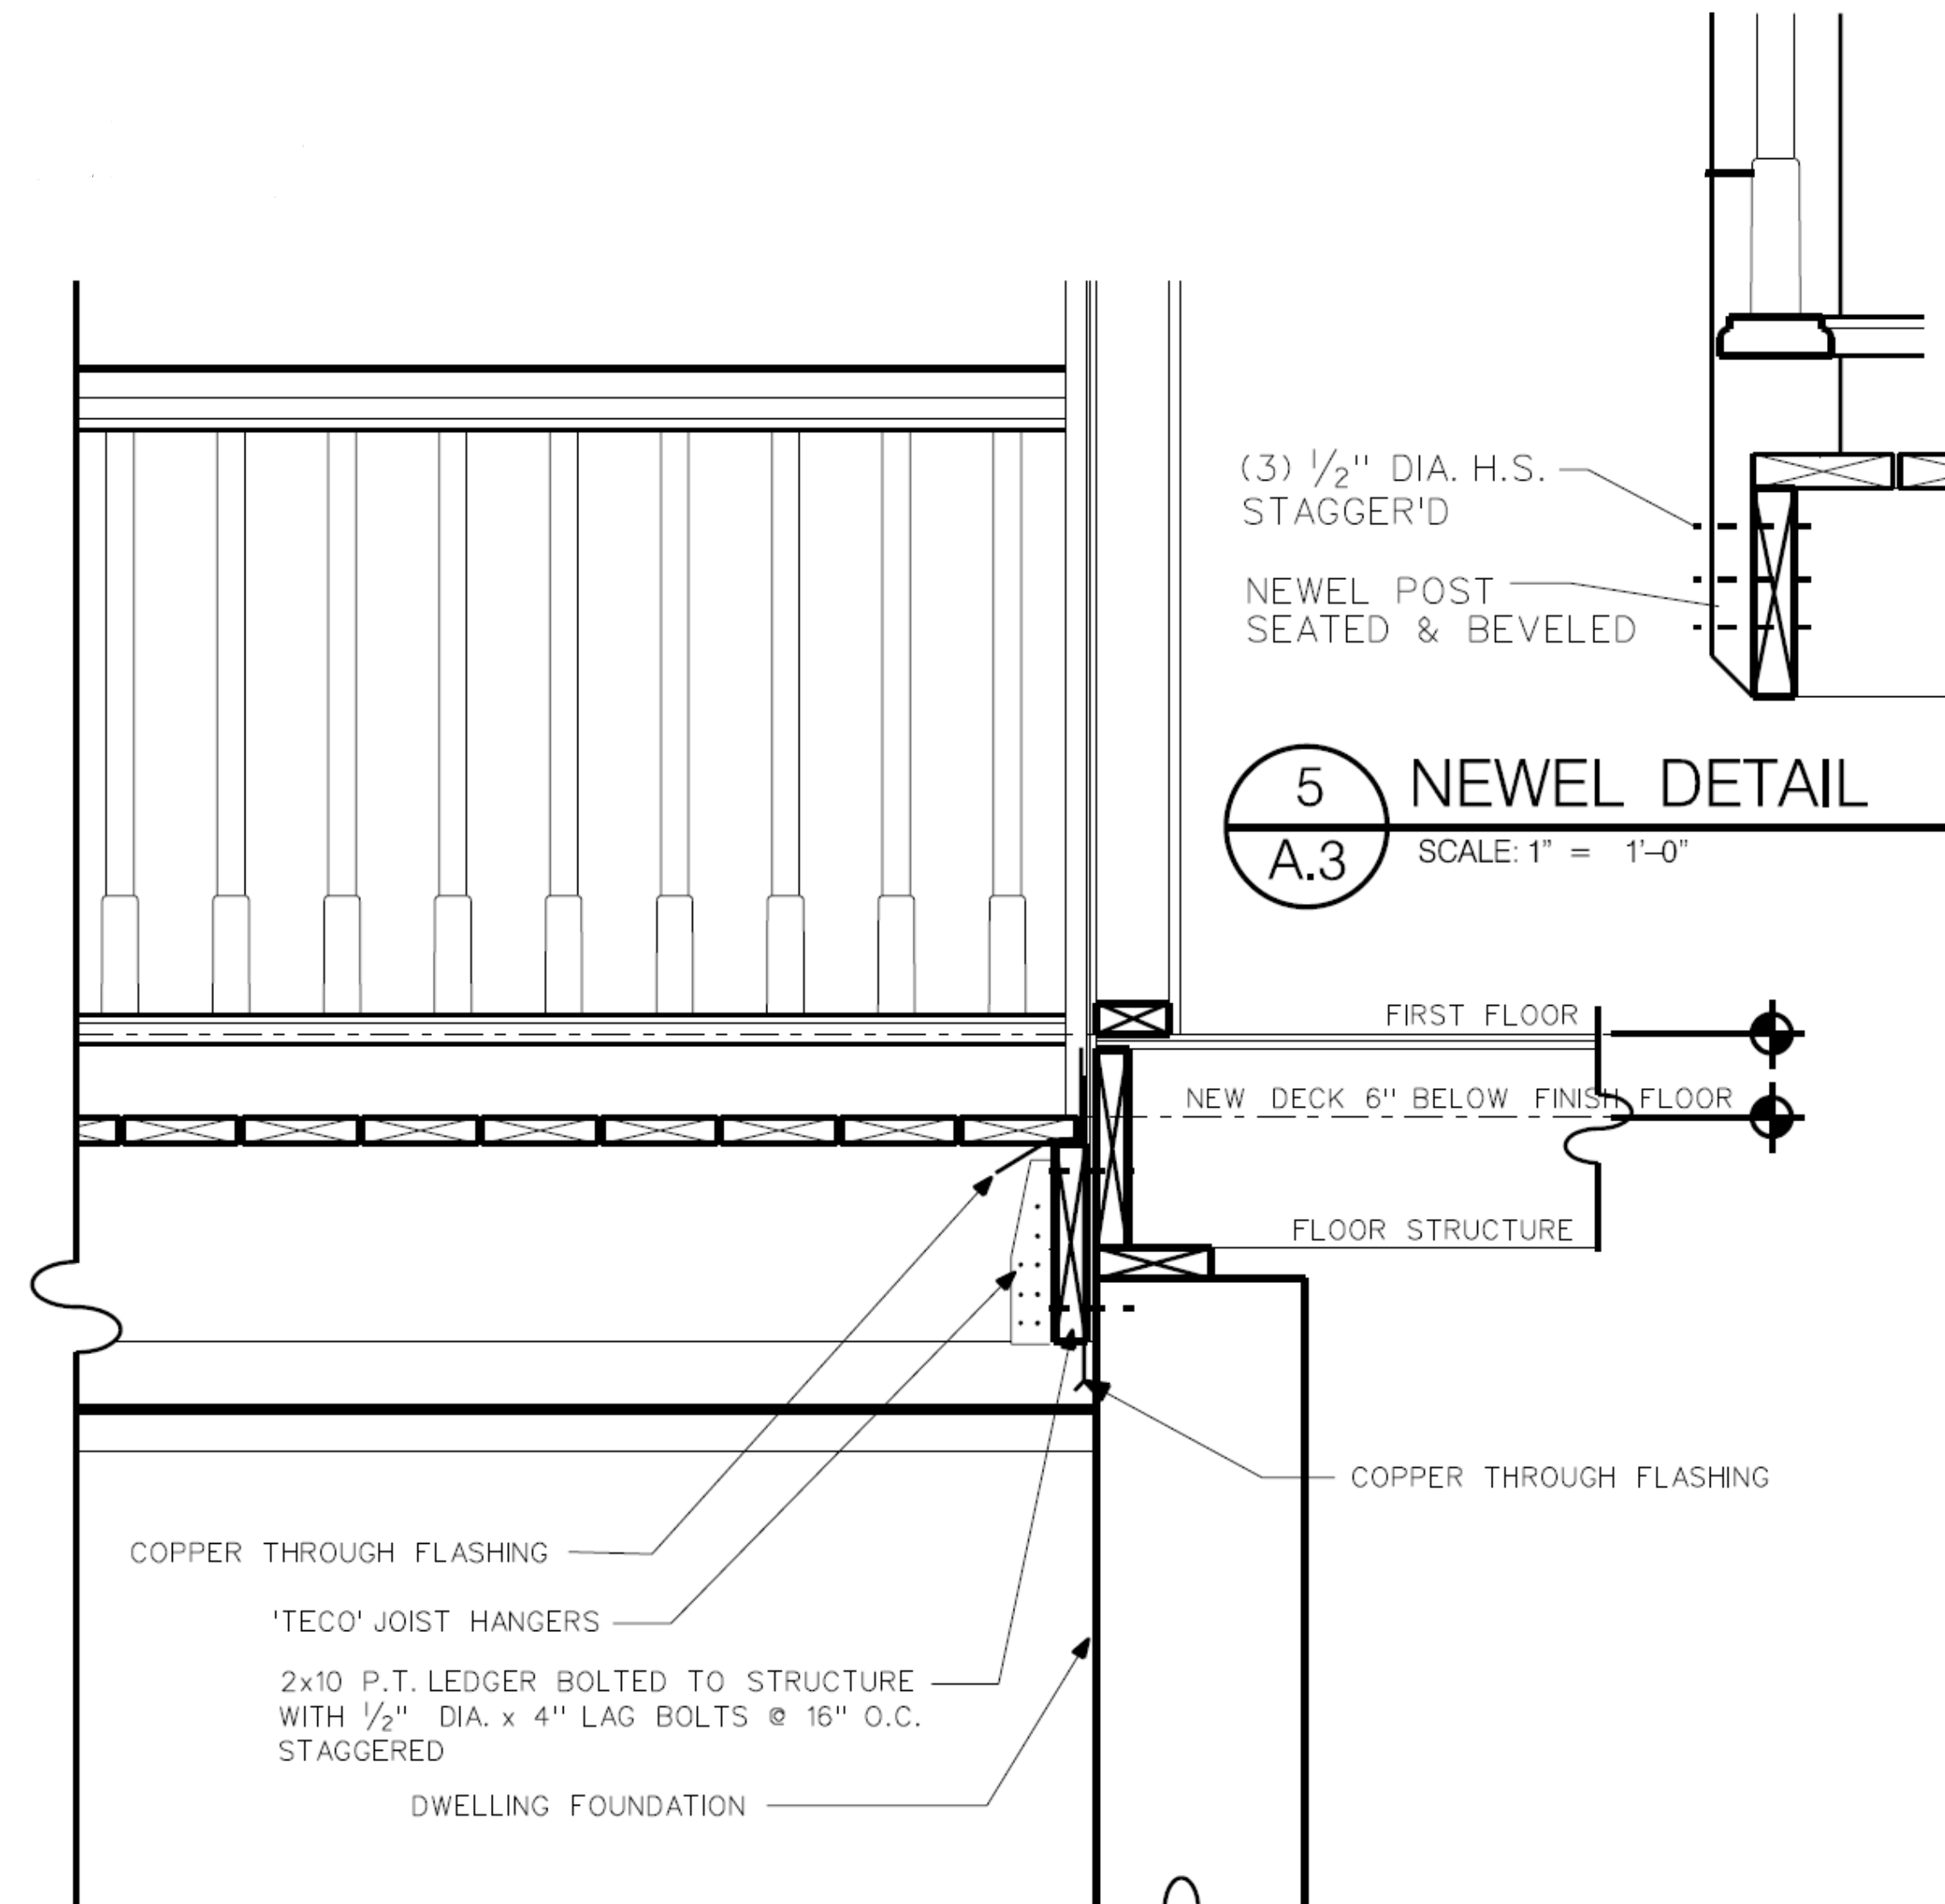A.3



4 SECTION & DETAIL THRU DECK & DWELLING

A.3

CONSULTANTS



CARDINAL DESIGN

211 Greenwood Avenue
Bethel, CT 06801
United States
www.cardinalde.com
projects@cardinalde.com

Raised Ranch

4 Old Neversink Road
Danbury Connecticut 06811
United States



CASALI COMPANIES
BUILDING ON TRUST

211 Greenwood Avenue
Bethel, CT 06801
United States
www.casalicompanies.com
projects@casalicompanies.com

PROJECT NO: 1006

MODEL FILE:

4 Old Neversink Road.pln

DRAWN BY: Jim Casali, Jr.

COPYRIGHT: 2025

SHEET TITLE

Section & Details

8